


PLANS CANNOT BE REPRODUCED, REDESIGNED OR COPIED AND ARE FOR THE ONE TIME USE FOR SAID INVOICE OR ADDRESS SHOWN. INFRINGEMENT OF THESE PLANS IN ANY WAY WILL FALL UNDER THE U.S. COPYRIGHT LAWS.

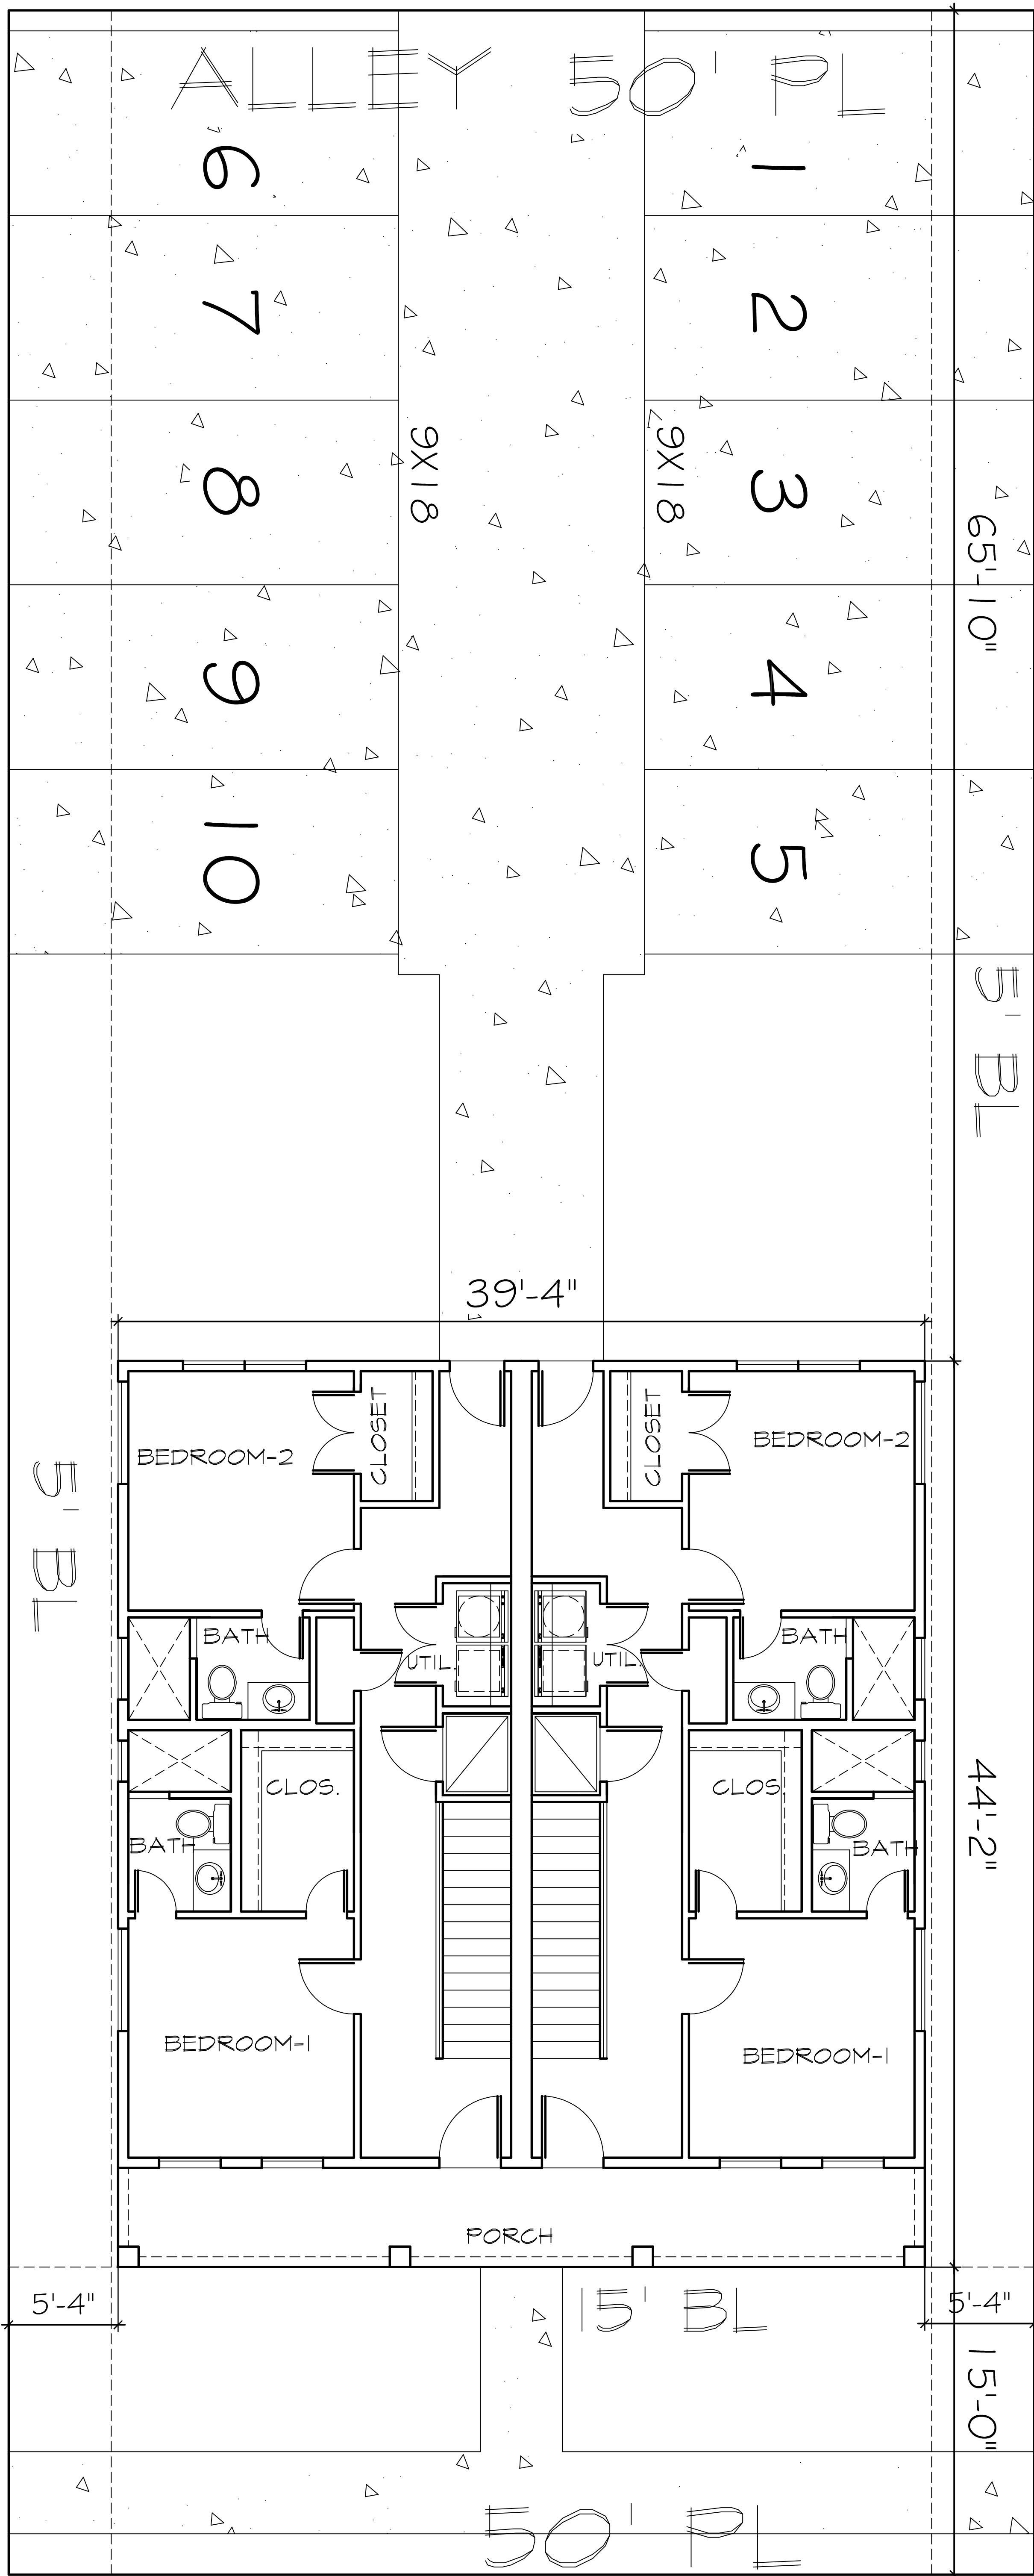


125' PL

5' BL

15' BL

50' PL



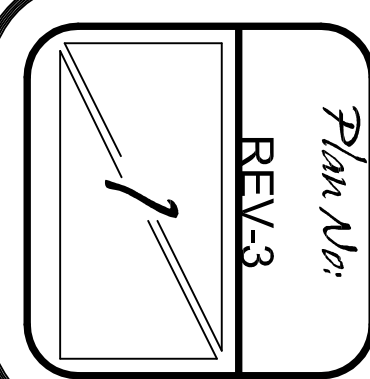


GOLDEN STAR ROCK INVESTMENTS

LOT:	BLK:	13-6
ADDRESS:	3144 WAYSIDE ADD	
SUBDIVISION:	BYERS / MCCART ADD	
CITY:	FORT WOTH	
COUNTY:	TARRANT	
STATE:	TX	
SCALE:	3/16"	

Doug Herron.com
Residential Designs
817-538-2910

EMAIL: dougsplans@aol.com WEBSITE: dougherron.com

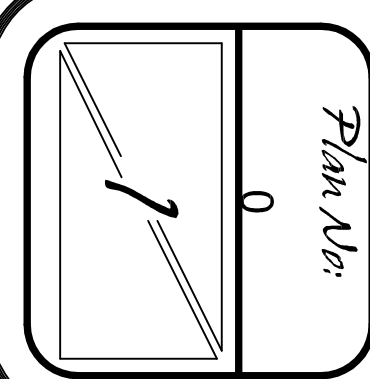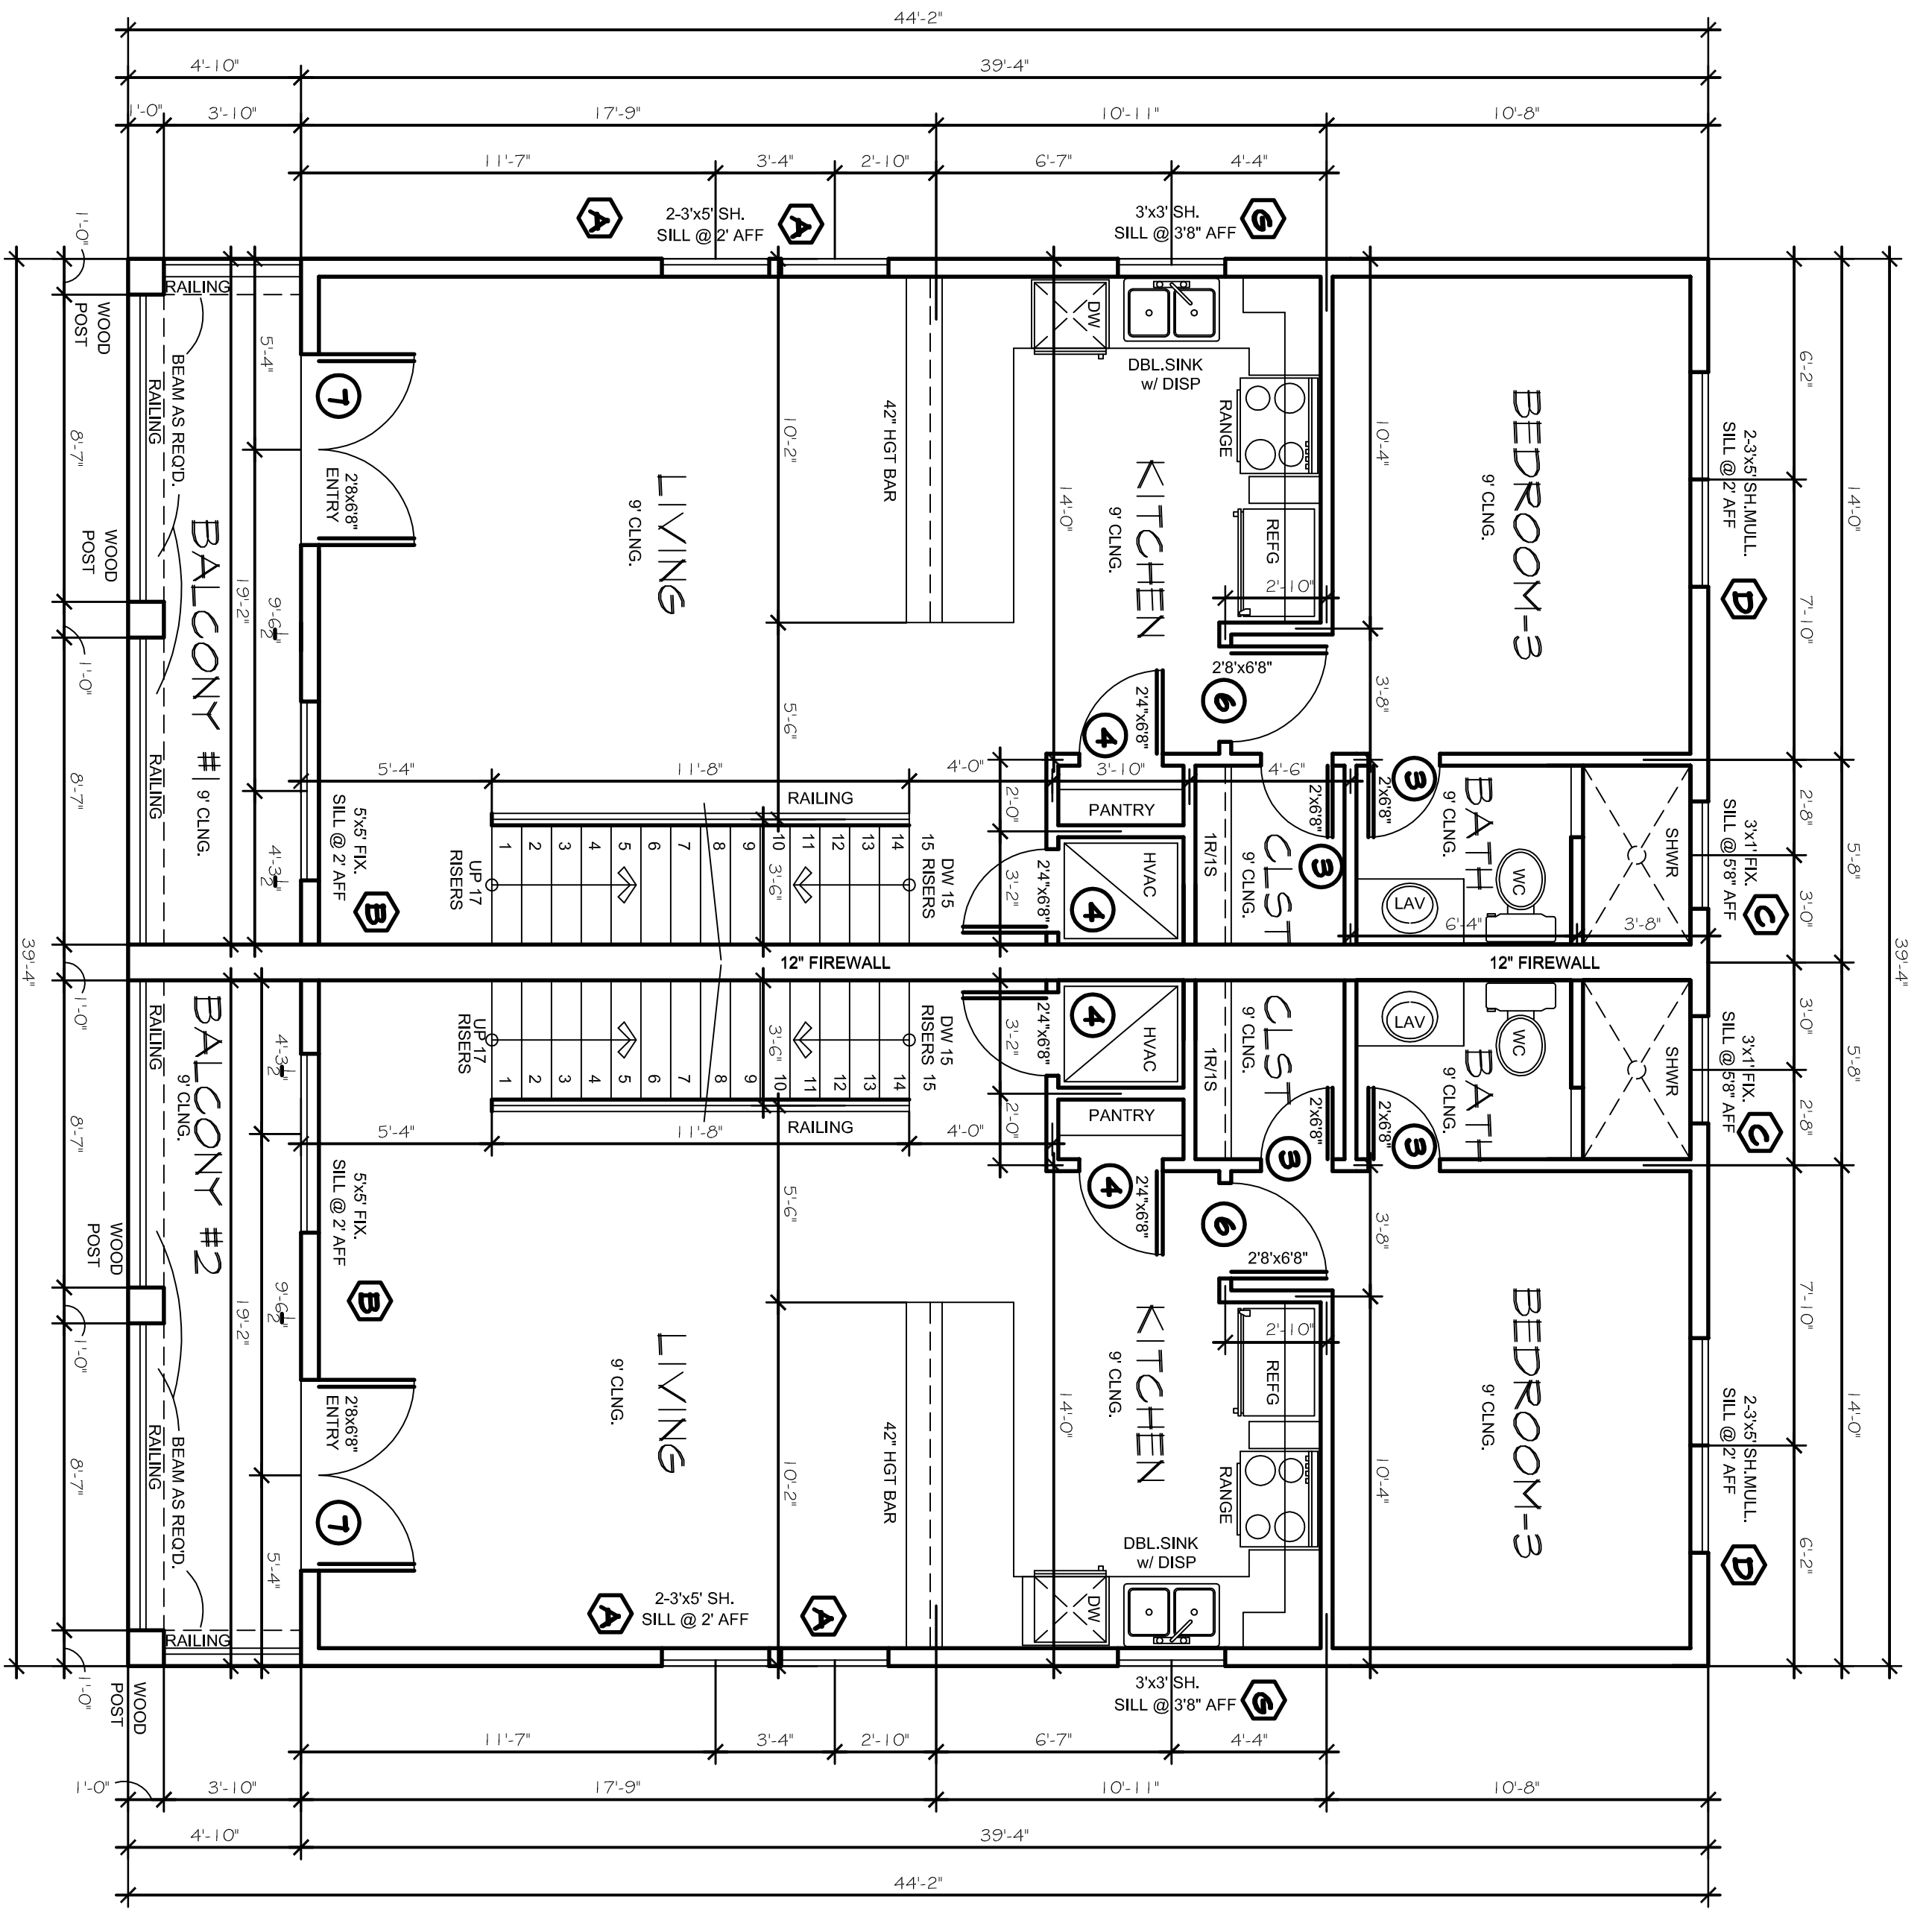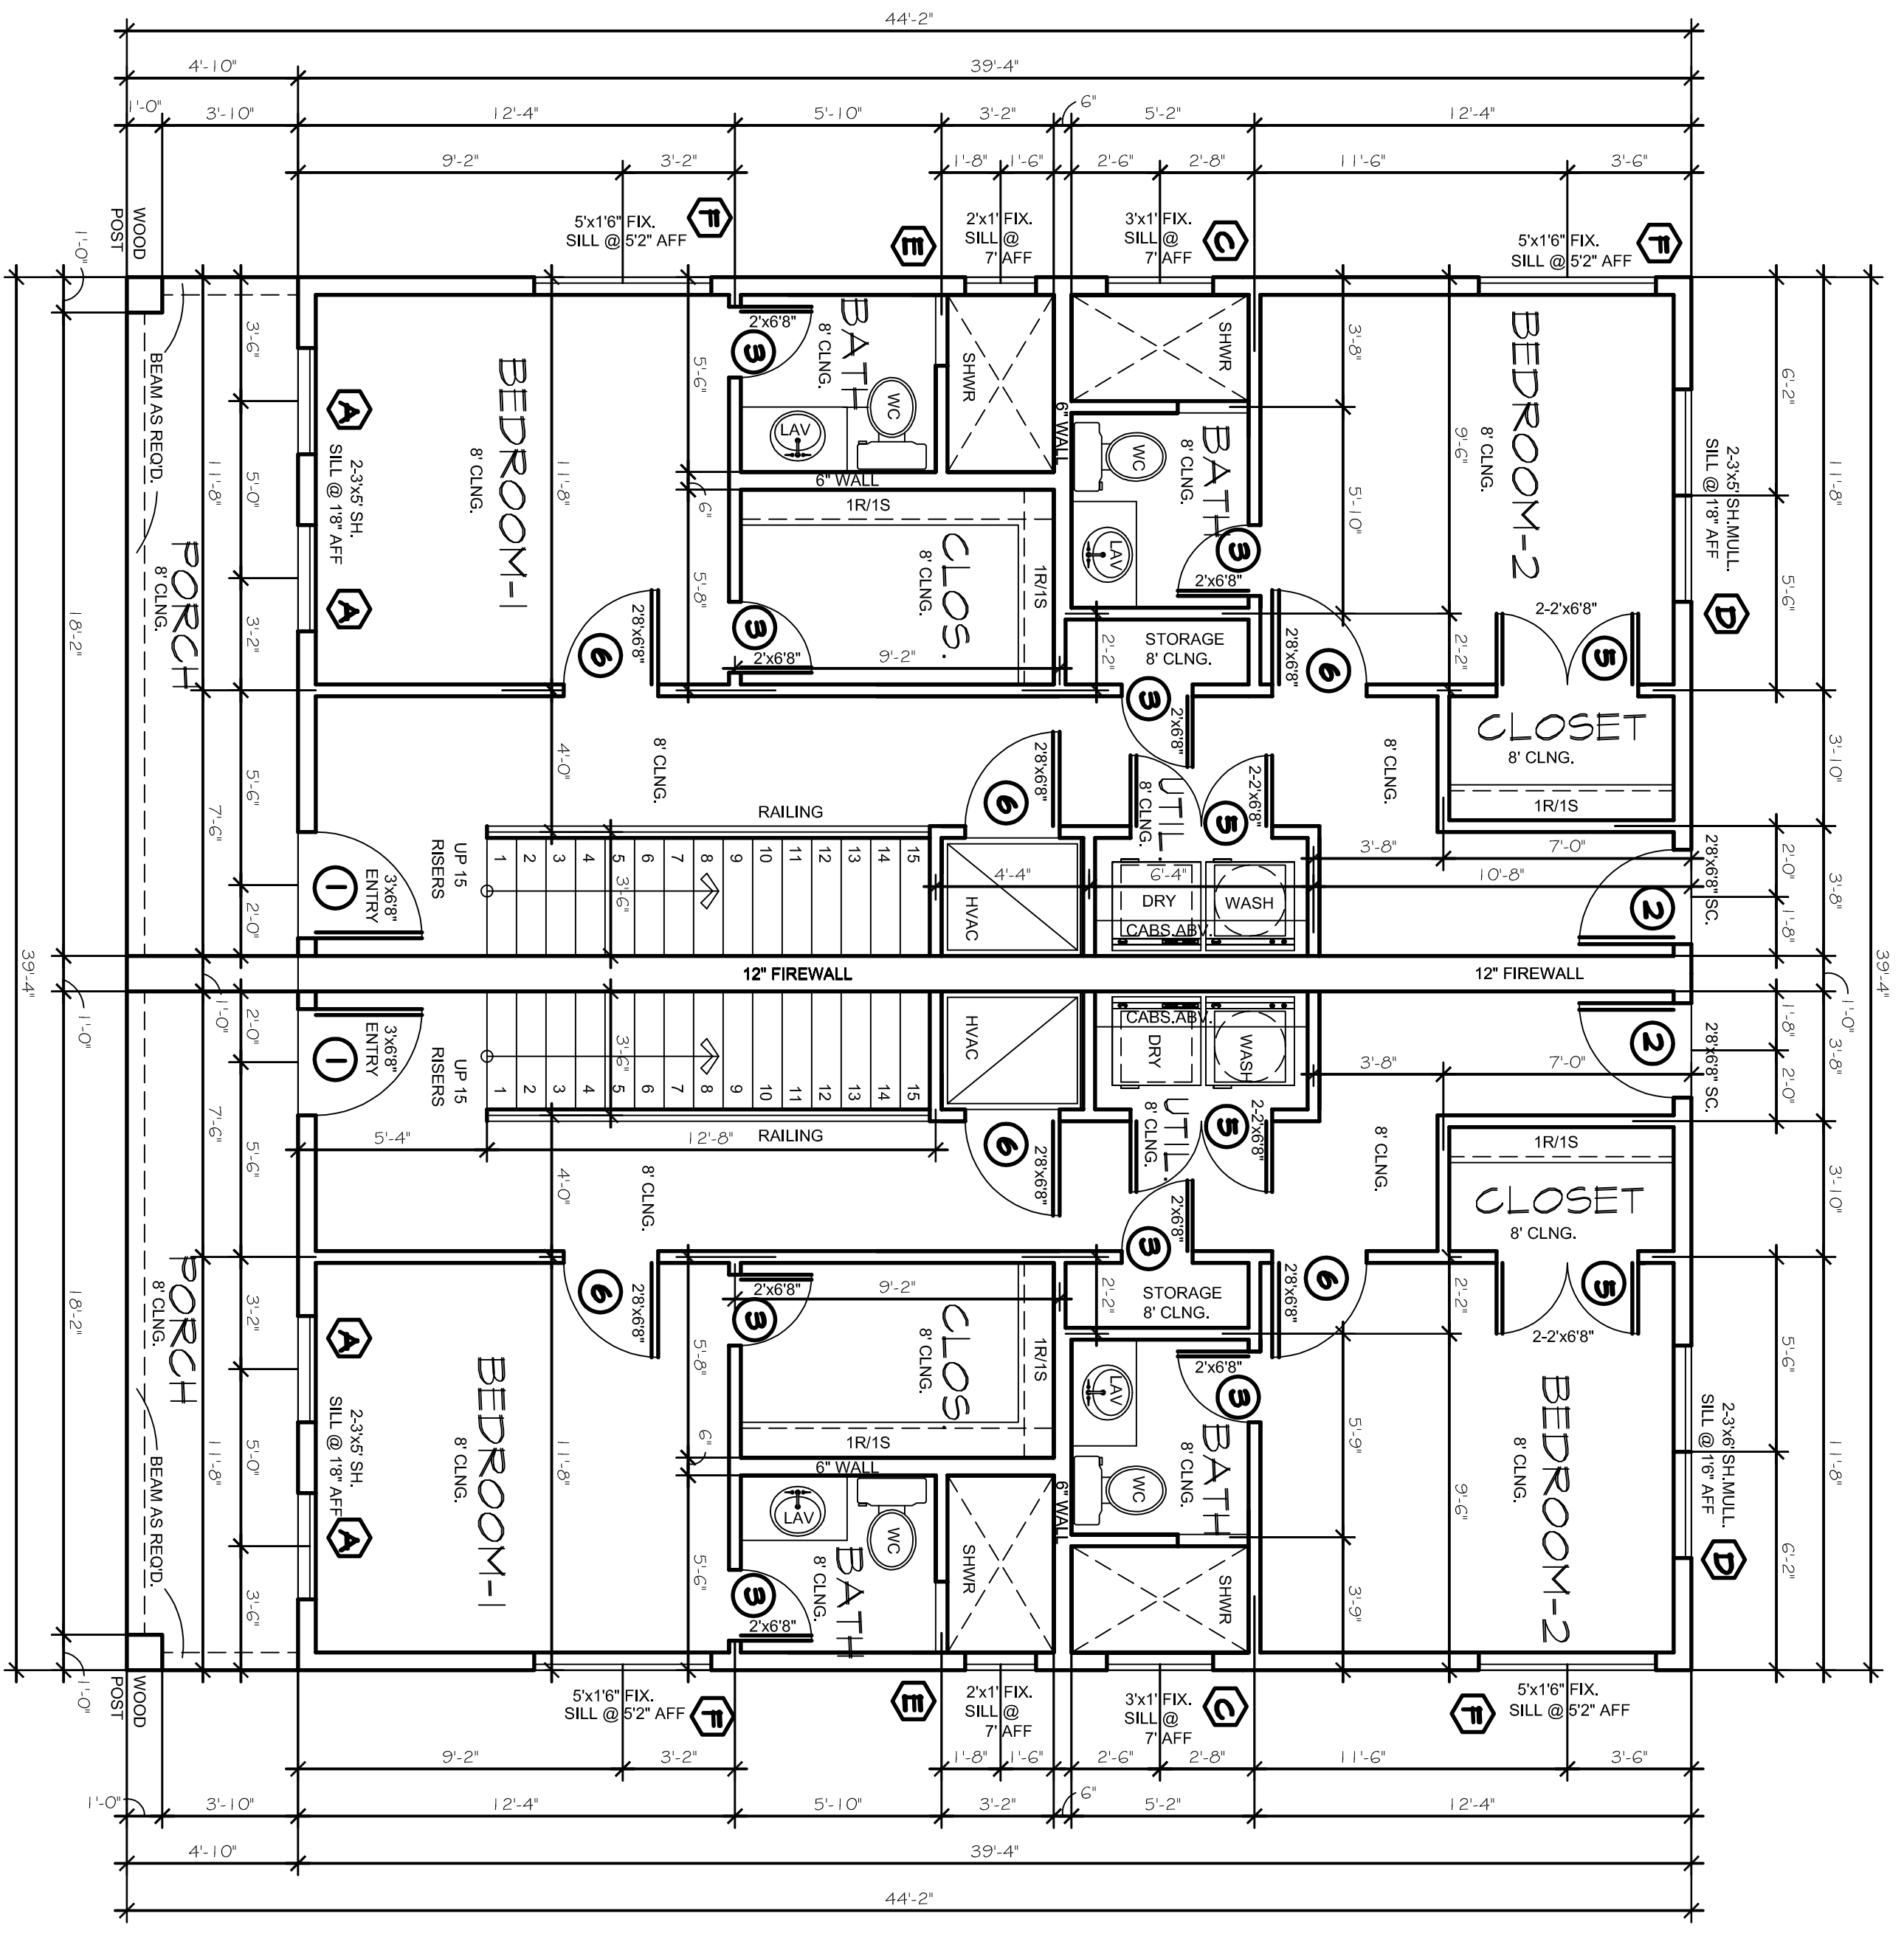


GOLDEN STAR ROCK INVESTMENTS


LOT:	BLK:
ADDRESS:	
SUBDIVISION:	
CITY:	
COUNTY:	
STATE:	TX
SCALE:	3/16"

Doug Herron.com
Residential Designs
817-538-2910

EMAIL: dougplans@aol.com WEBSITE: dougherron.com

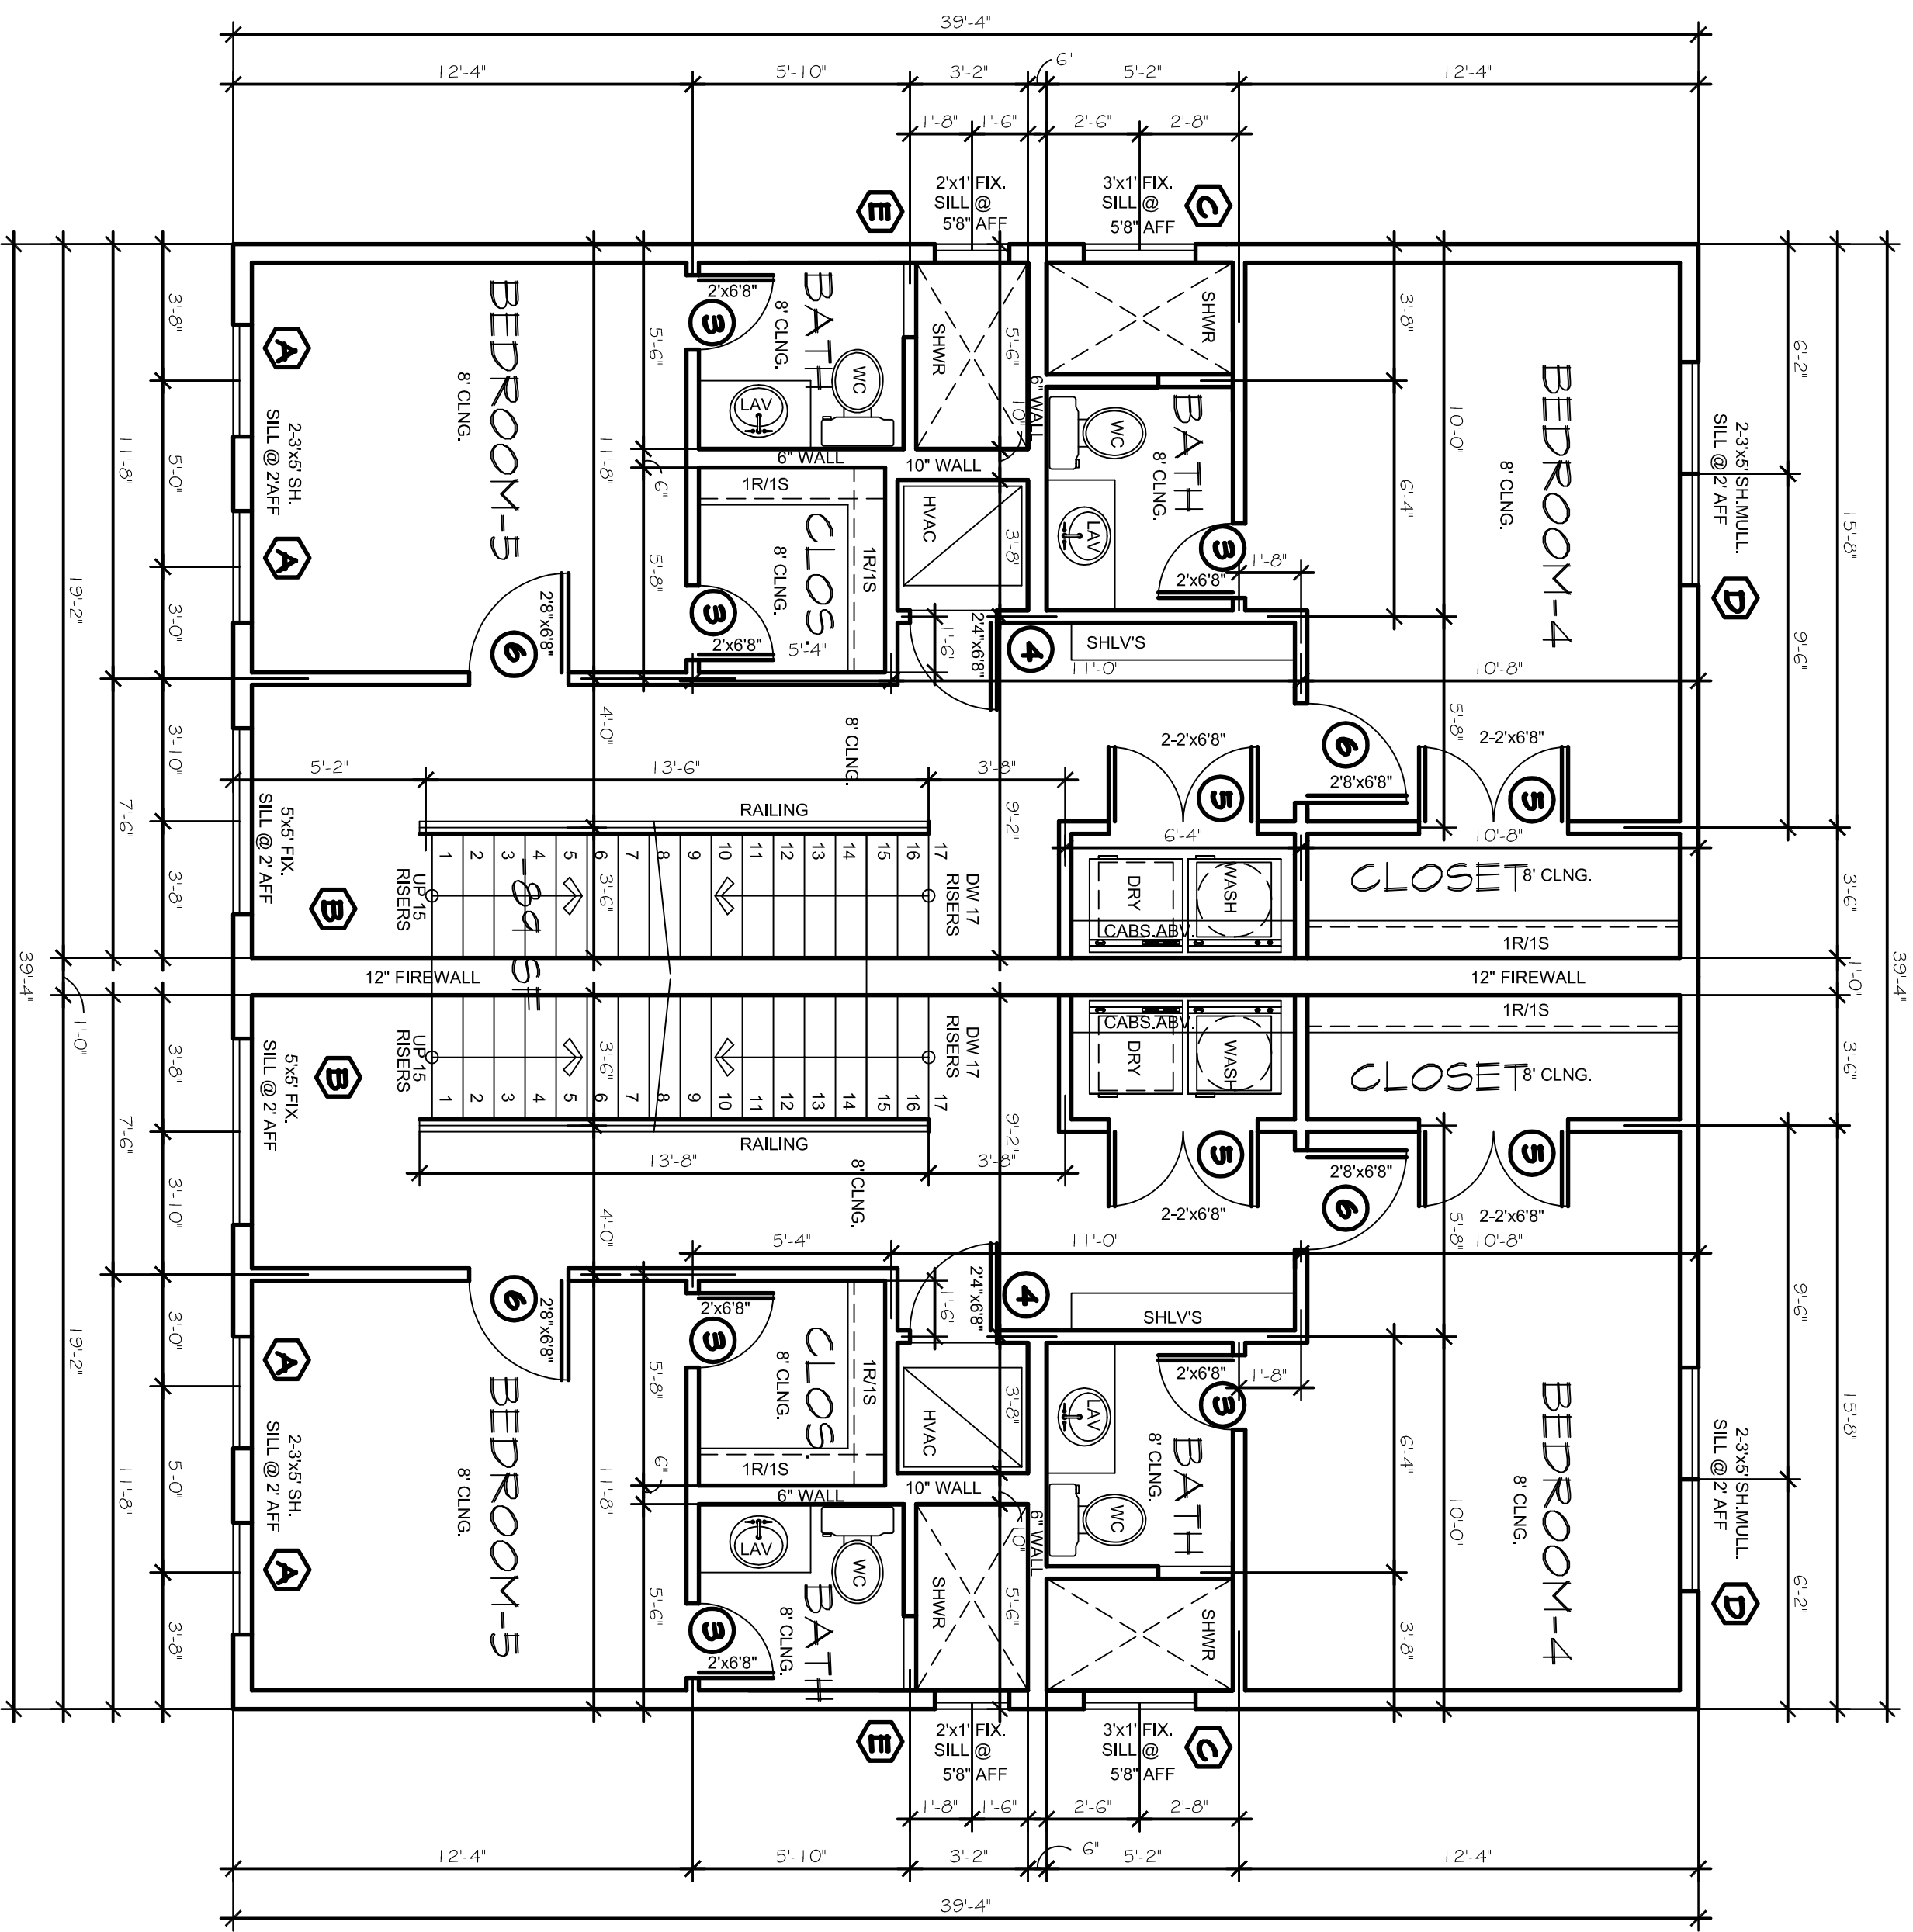

THIRD FLOOR
SCALE: 1/4\"/>

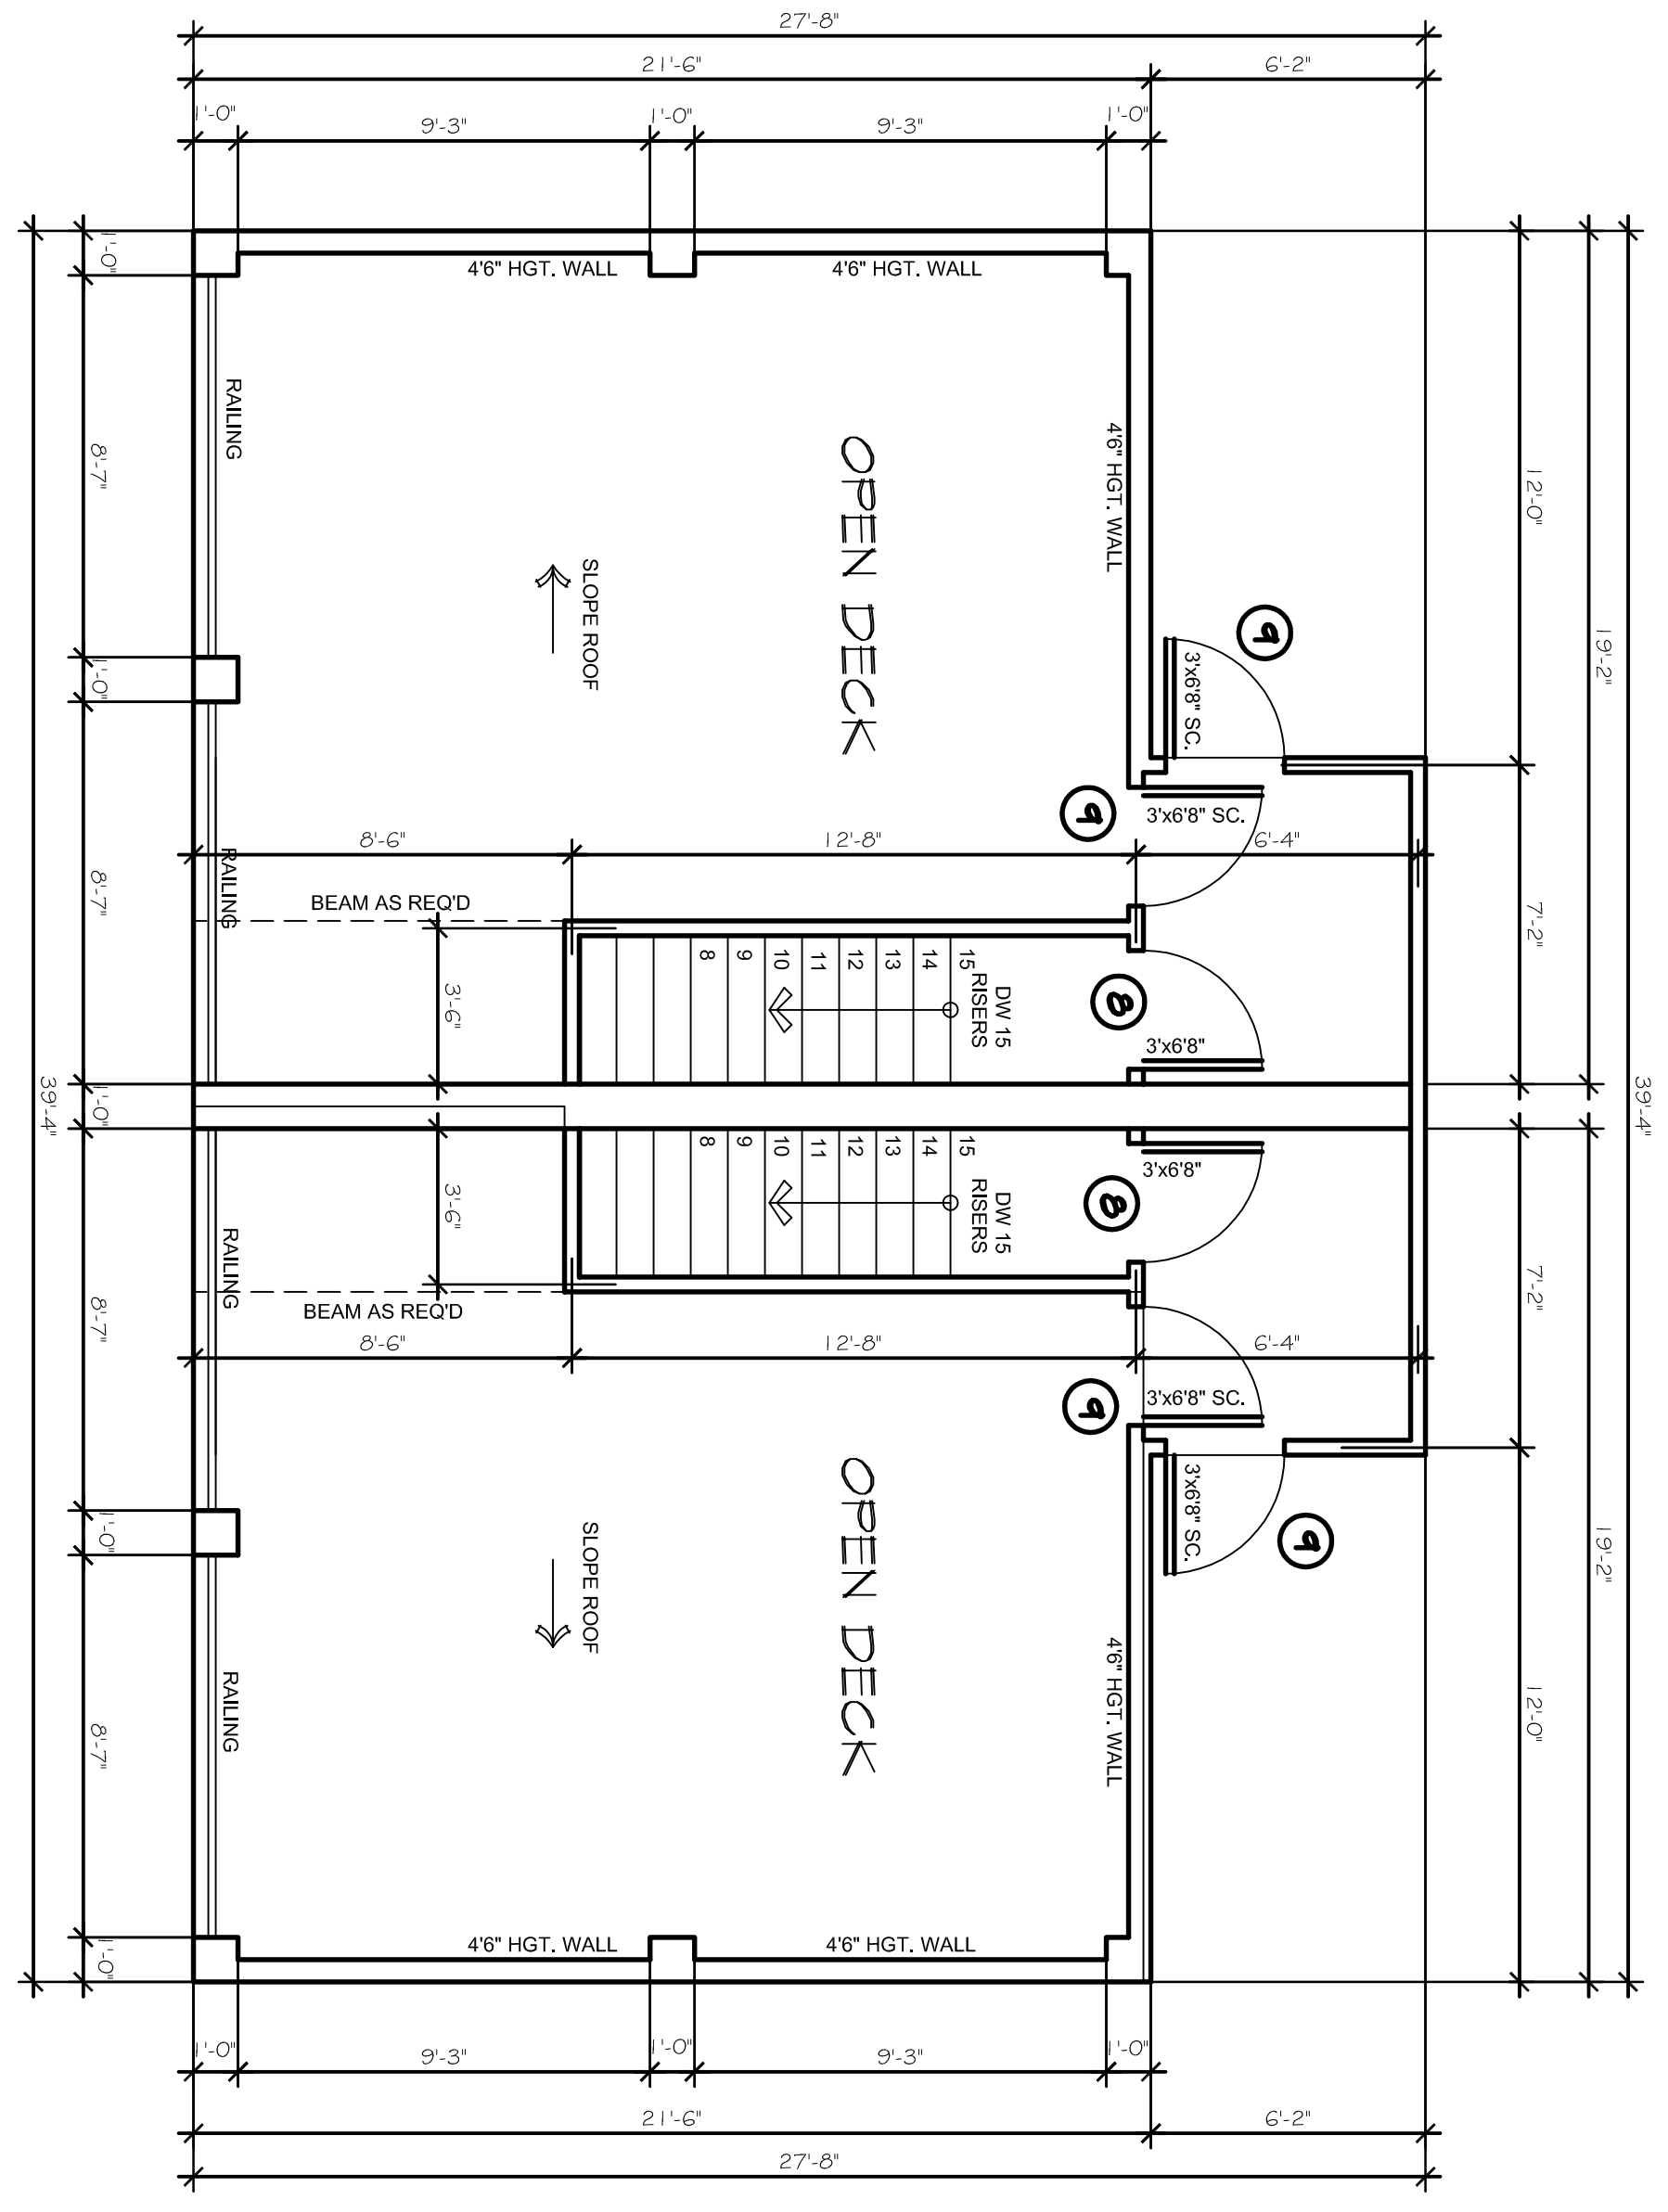

FOURTH FLOOR / ROOF PLAN
SCALE: 1/16\"/>

HOUSE SQUARE FOOT	
FIRST FLOOR	1547
SECOND FLOOR	1452
THIRD FLOOR	4557
TOTAL (AO) - WITH BRK	3456
PORCH	180
BALCONY #1	53
BALCONY #2	378
TOTAL (AOH-HB)	3763
DECK - 366 EACH	732
TOTAL (AUH)	5863

DOOR SCHEDULE			
MARK	QTY	SIZE	TYPE
1	2	1-5/8\"/>	
2	2	2-2\"/>	
3	18	2-2\"/>	
4	6	2-2\"/>	
5	8	1-2\"/>	
6	2	1-2\"/>	
7	2	1-2\"/>	
8	2	3-6\"/>	
9	4	3-6\"/>	


WINDOW SCHEDULE			
MARK	QTY	SIZE	TYPE
A	12	3-3\"/>	
B	4	5-8\"/>	
C	2	2-2\"/>	
D	4	2-2\"/>	
E	1	5-1\"/>	
F	1	5-1\"/>	
G	5	3-3\"/>	

Plan No. **2**


GOLDEN STAR ROCK INVESTMENTS

LOT: _____ BLK: _____
 ADDRESS: _____
 SUBDIVISION: _____
 CITY: _____
 COUNTY: _____
 STATE: TX
 SCALE: 1/4"


Doug Herron.com
 Residential Designs
 817-538-2910
 EMAIL: dougsplans@aol.com WEBSITE: dougherron.com

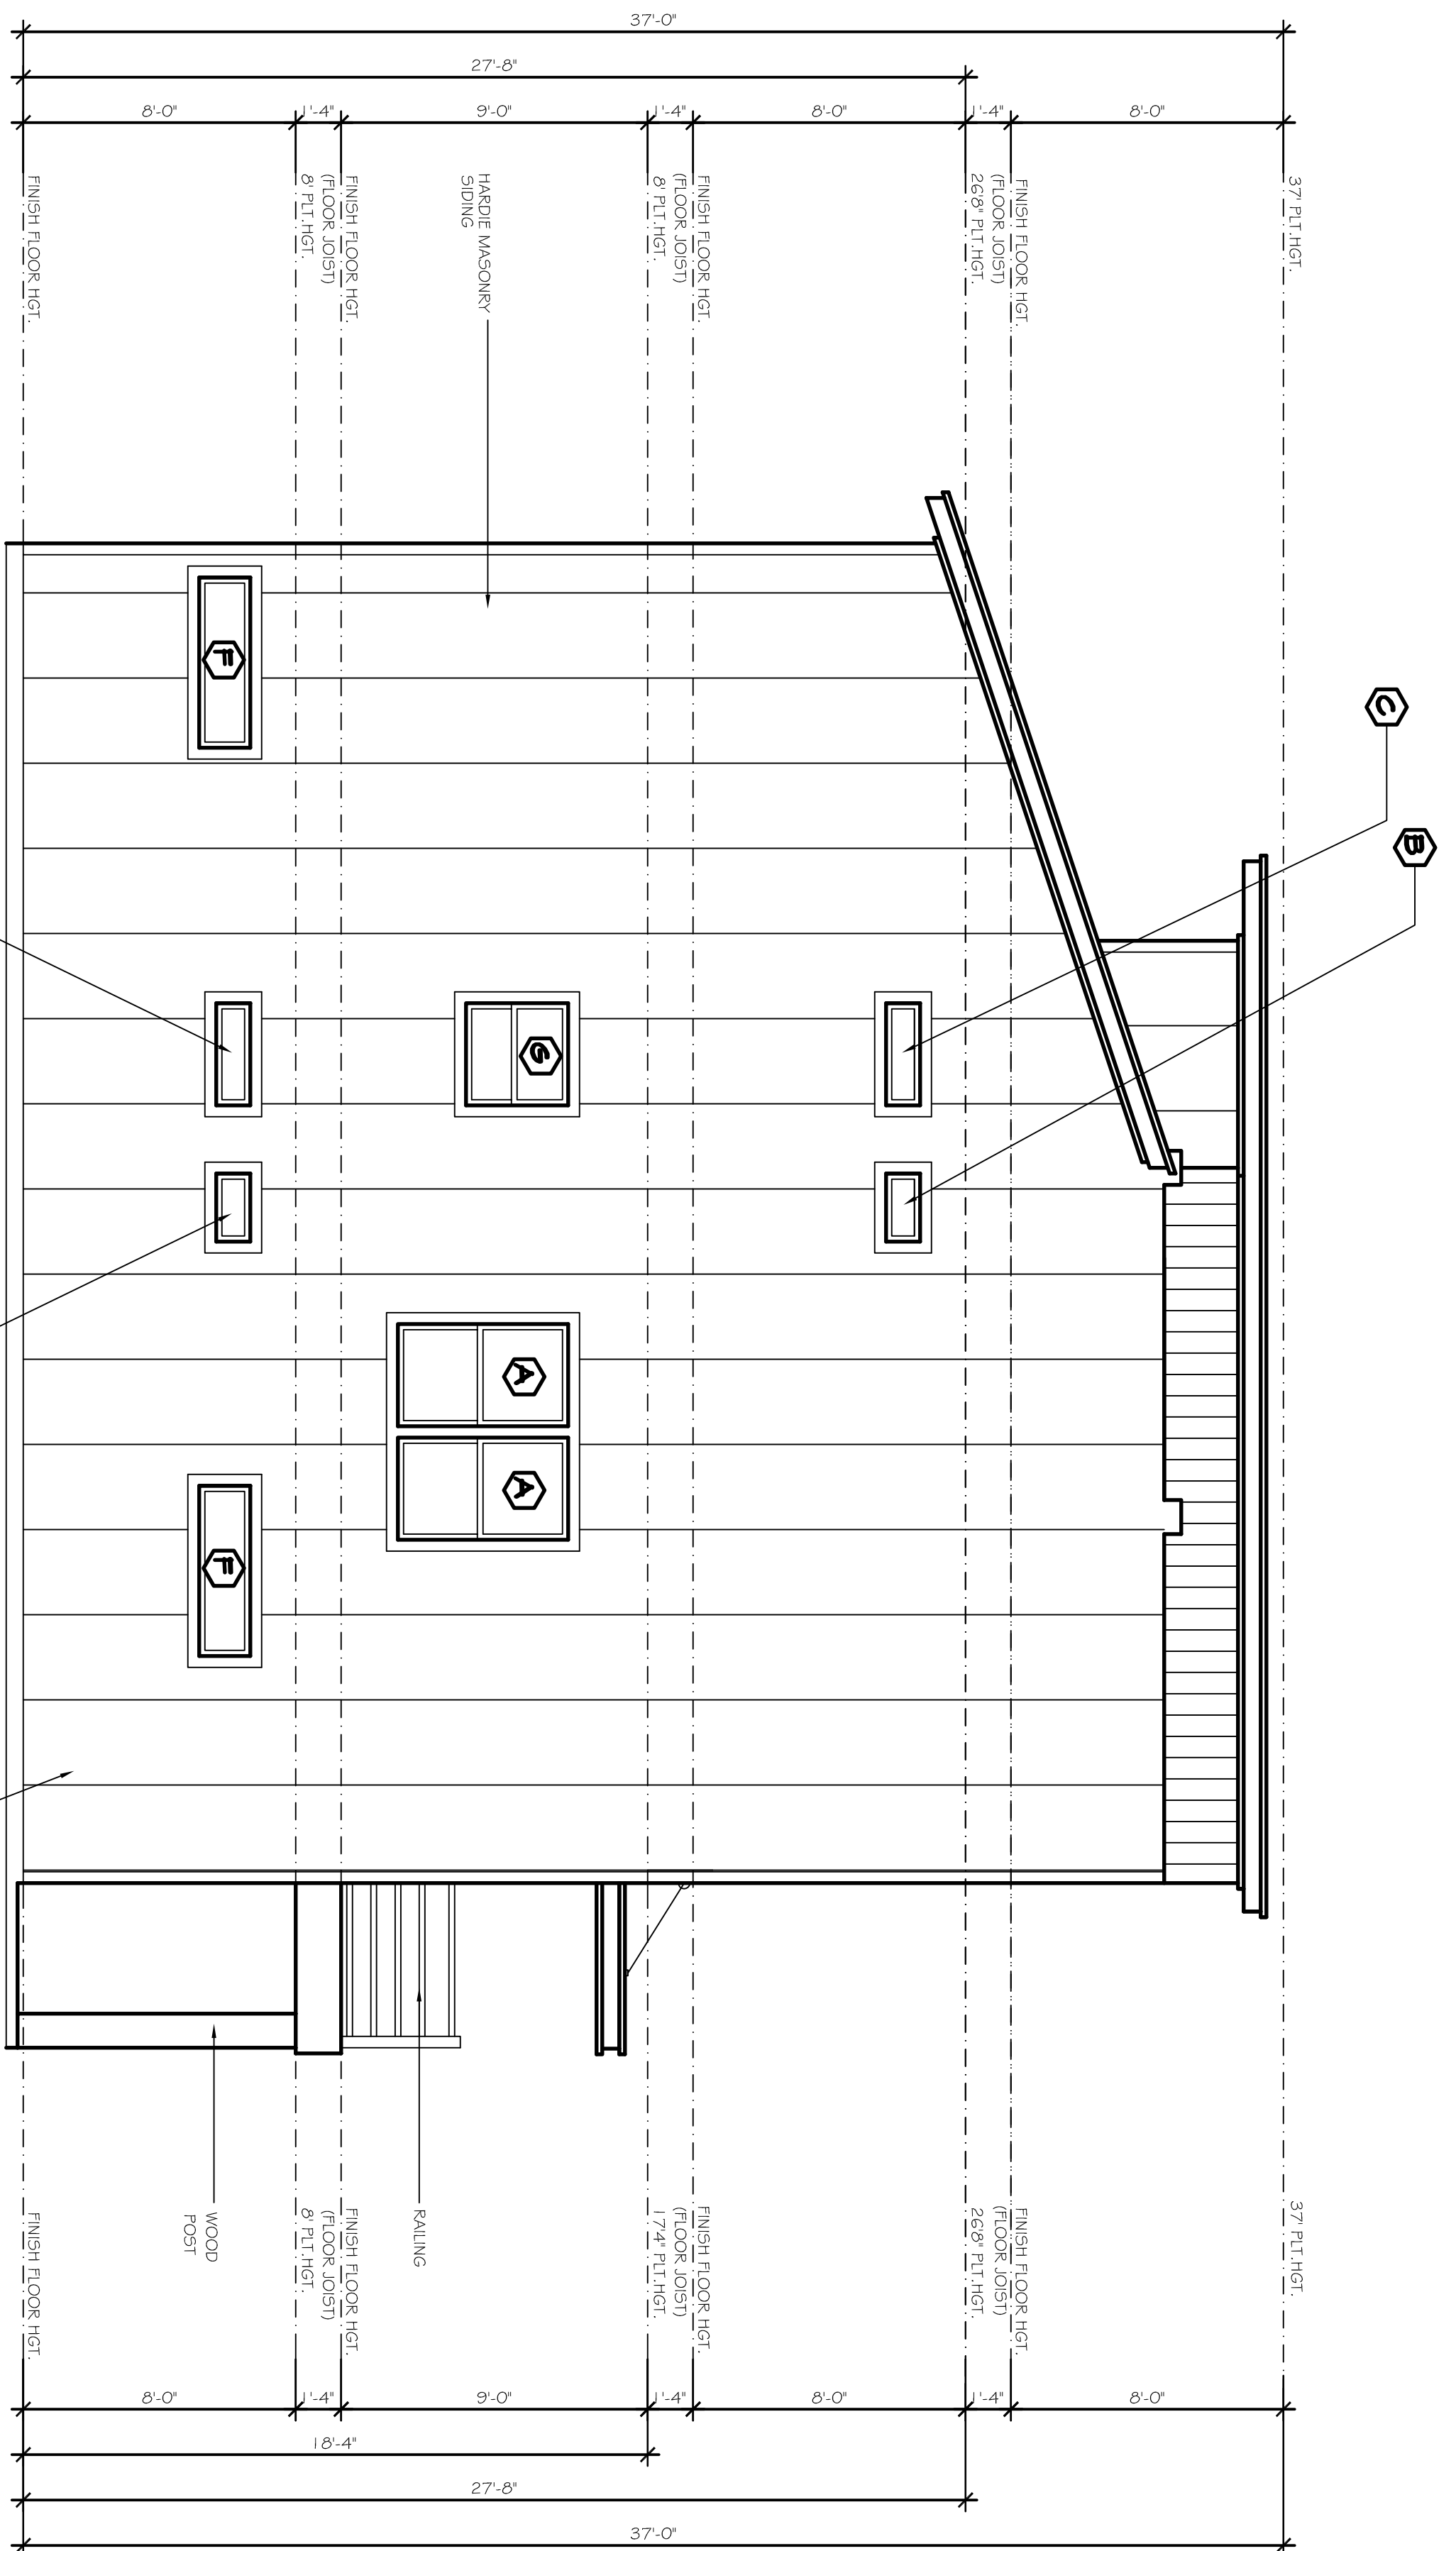

LEFT ELEVATION
SCALE: 1/4"=1'-0"

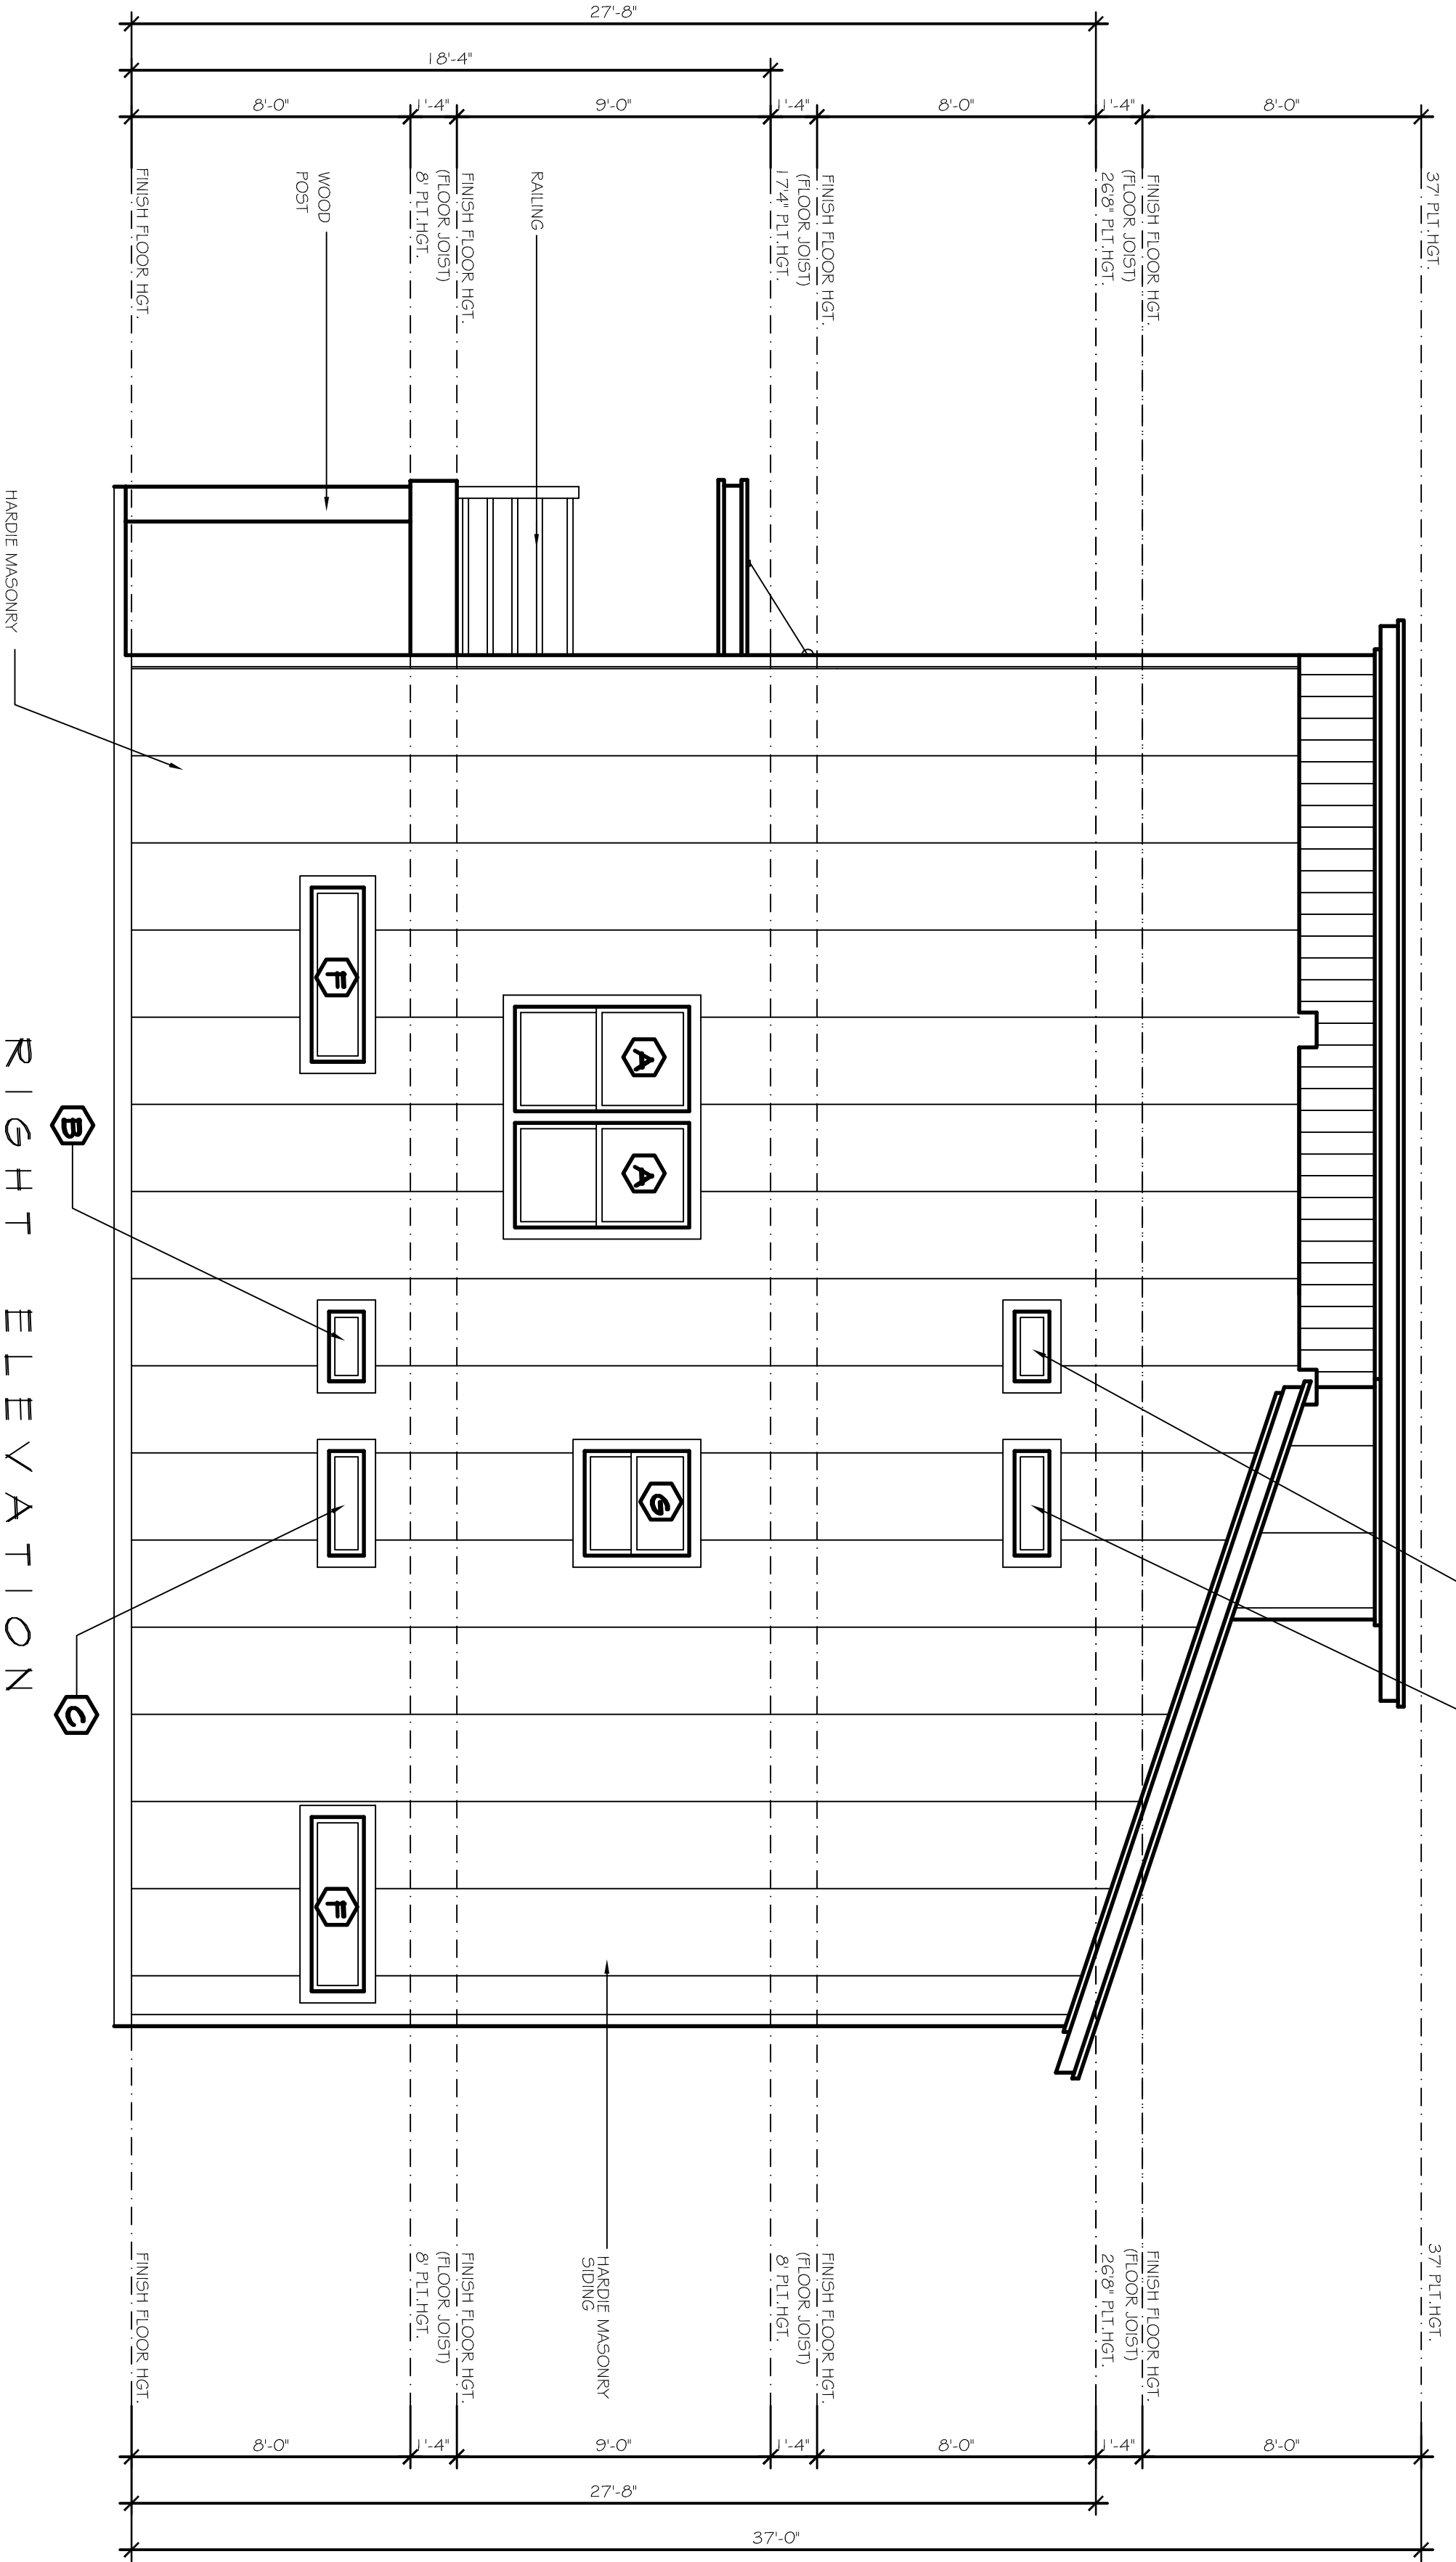

RIGHT ELEVATION
SCALE: 1/4"=1'-0"

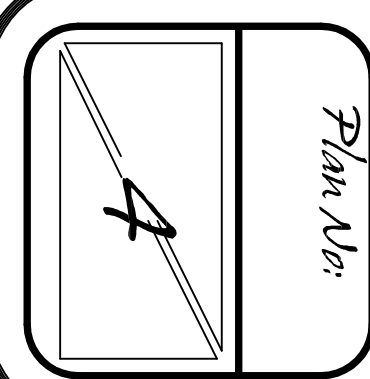


GOLDEN STAR ROCK INVESTMENTS


LOT:	BLK:
ADDRESS:	
SUBDIVISION:	
CITY:	
COUNTY:	
STATE:	TX
SCALE:	1/4"

Doug Herron.com
Residential Designs
817-538-2910


EMAIL: dougplans@aol.com WEBSITE: dougherron.com

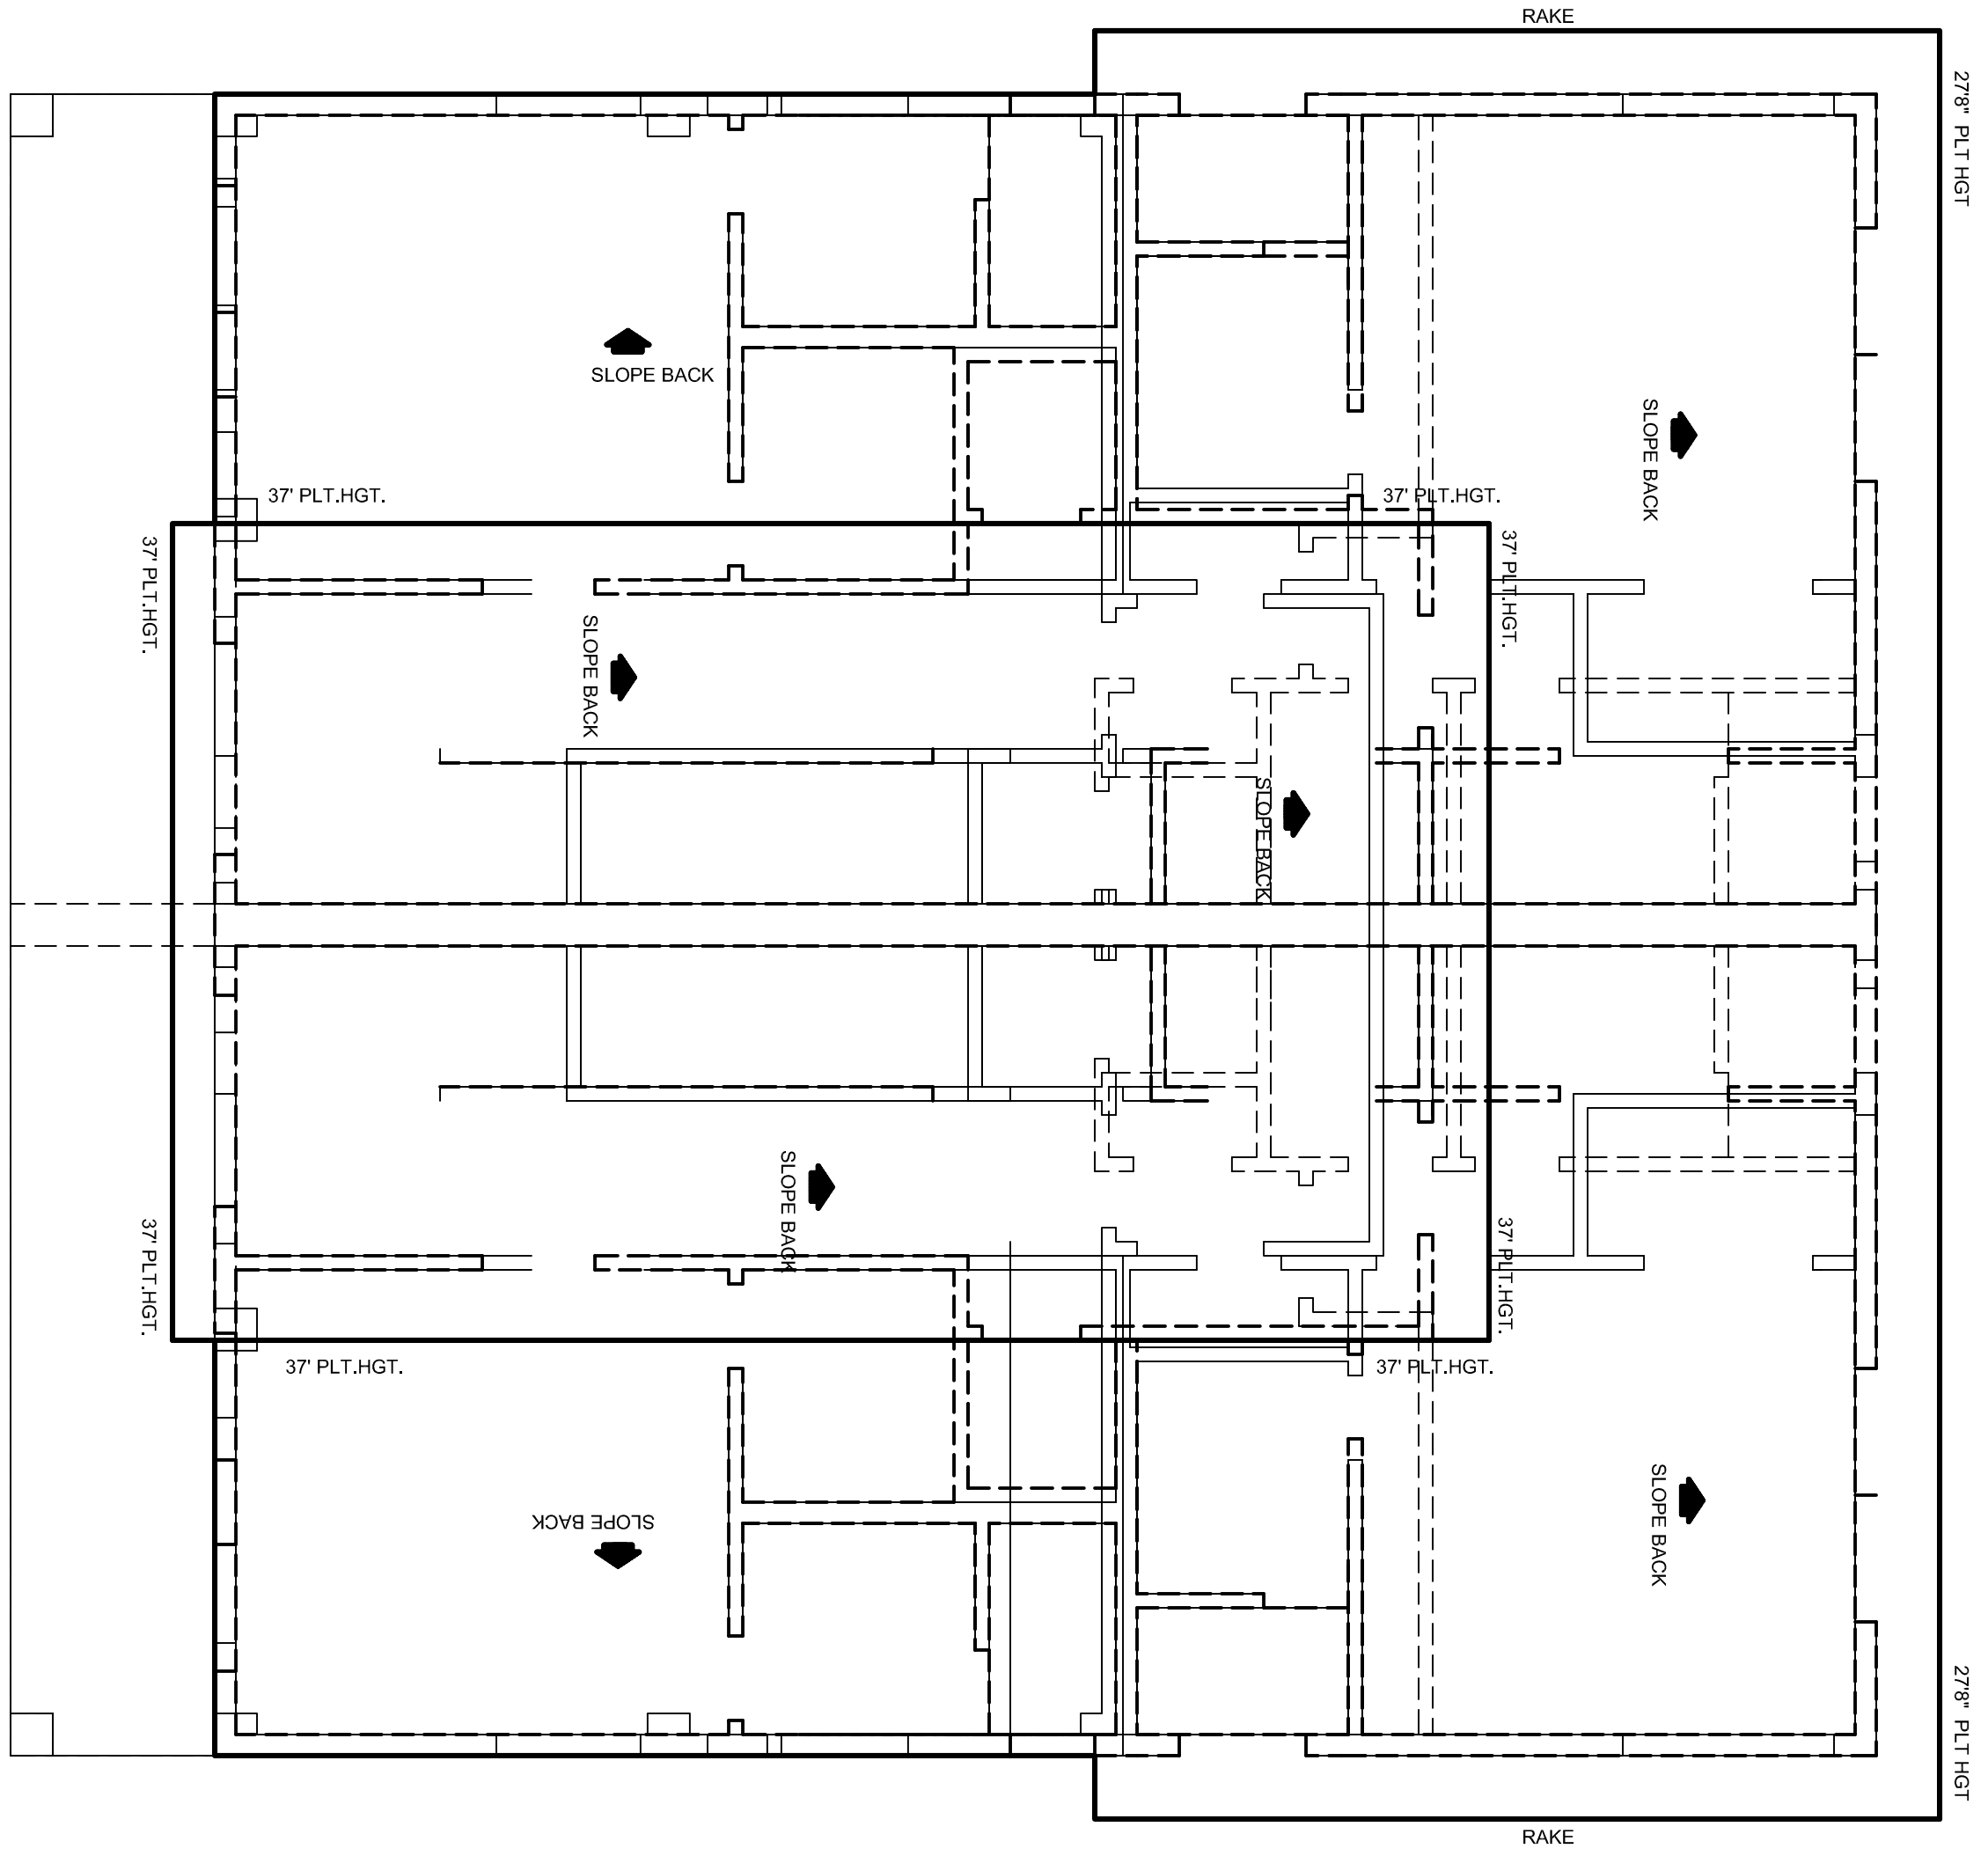

ROOF PLAN

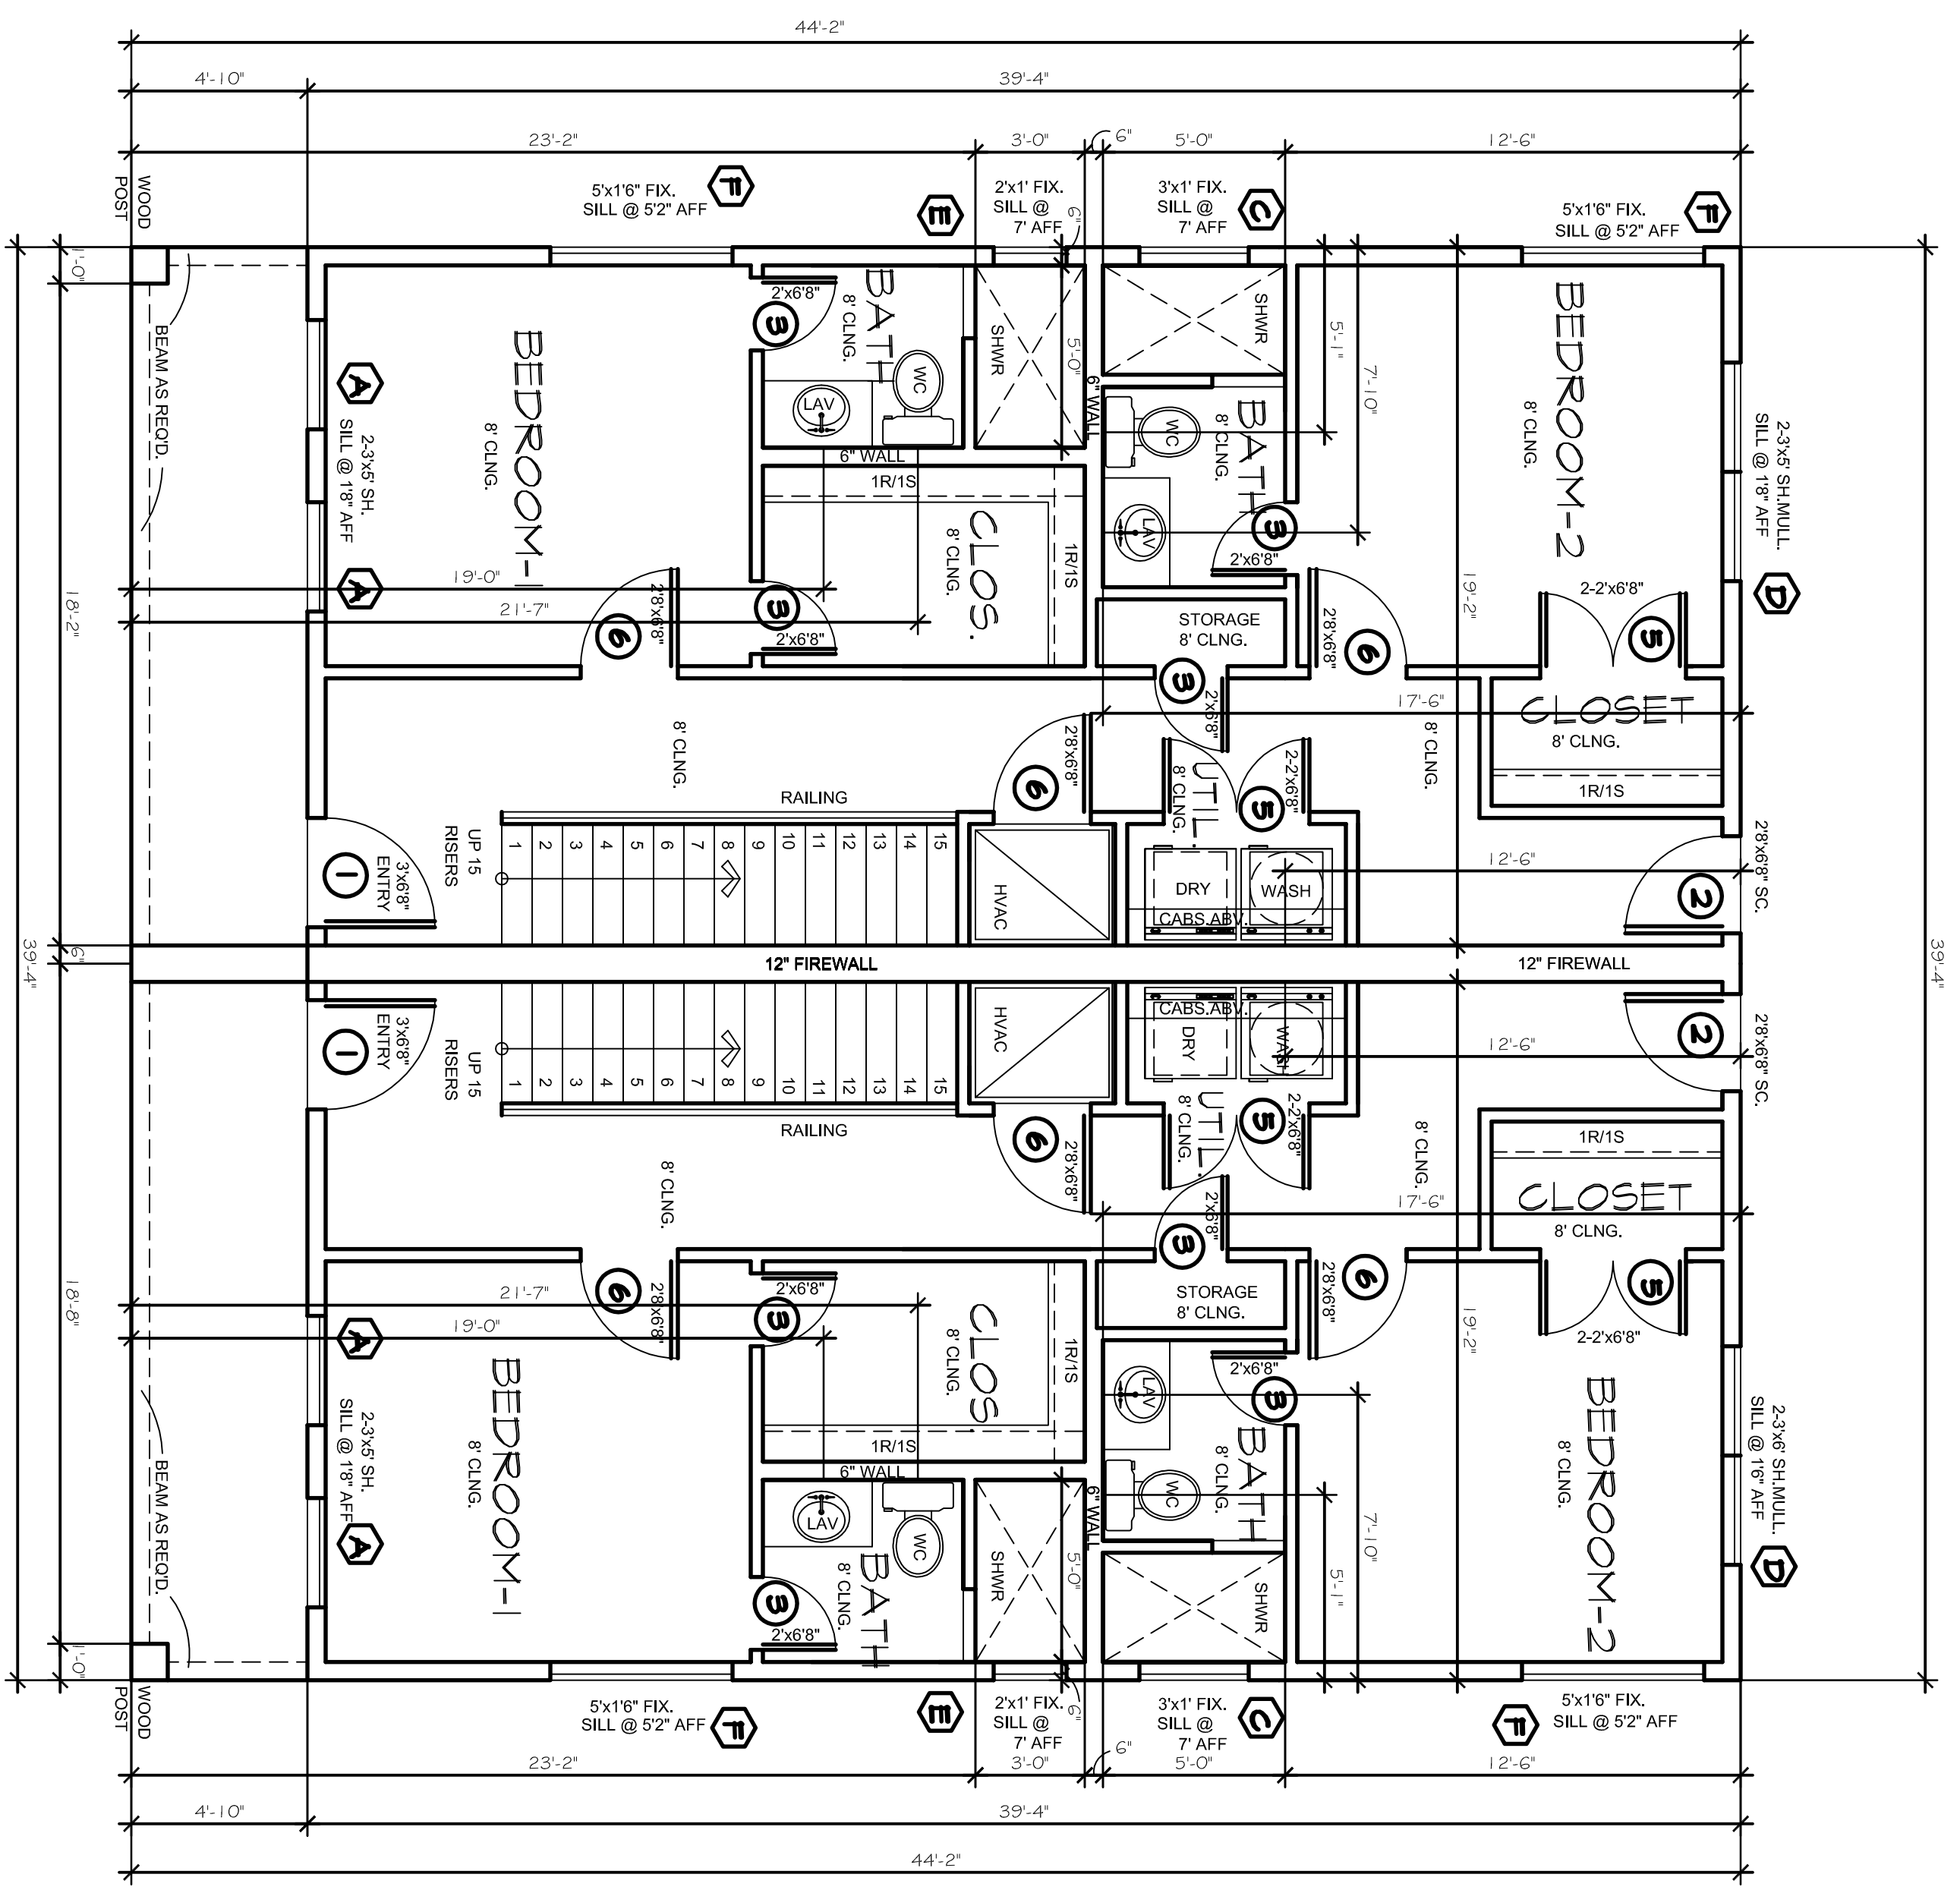

FORM BOARD & PLUMBING LAYOUT

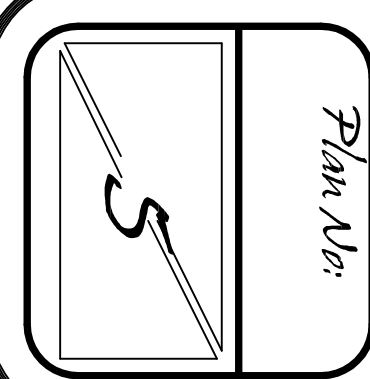


Plan No.

GOLDEN STAR ROCK INVESTMENTS

LOT:	BLK:
ADDRESS:	
SUBDIVISION:	
CITY:	
COUNTY:	
STATE:	TX
SCALE:	1/4"


Doug Herron.com
Residential Designs
817-538-2910

EMAIL: dougplans@aol.com WEBSITE: dougherron.com

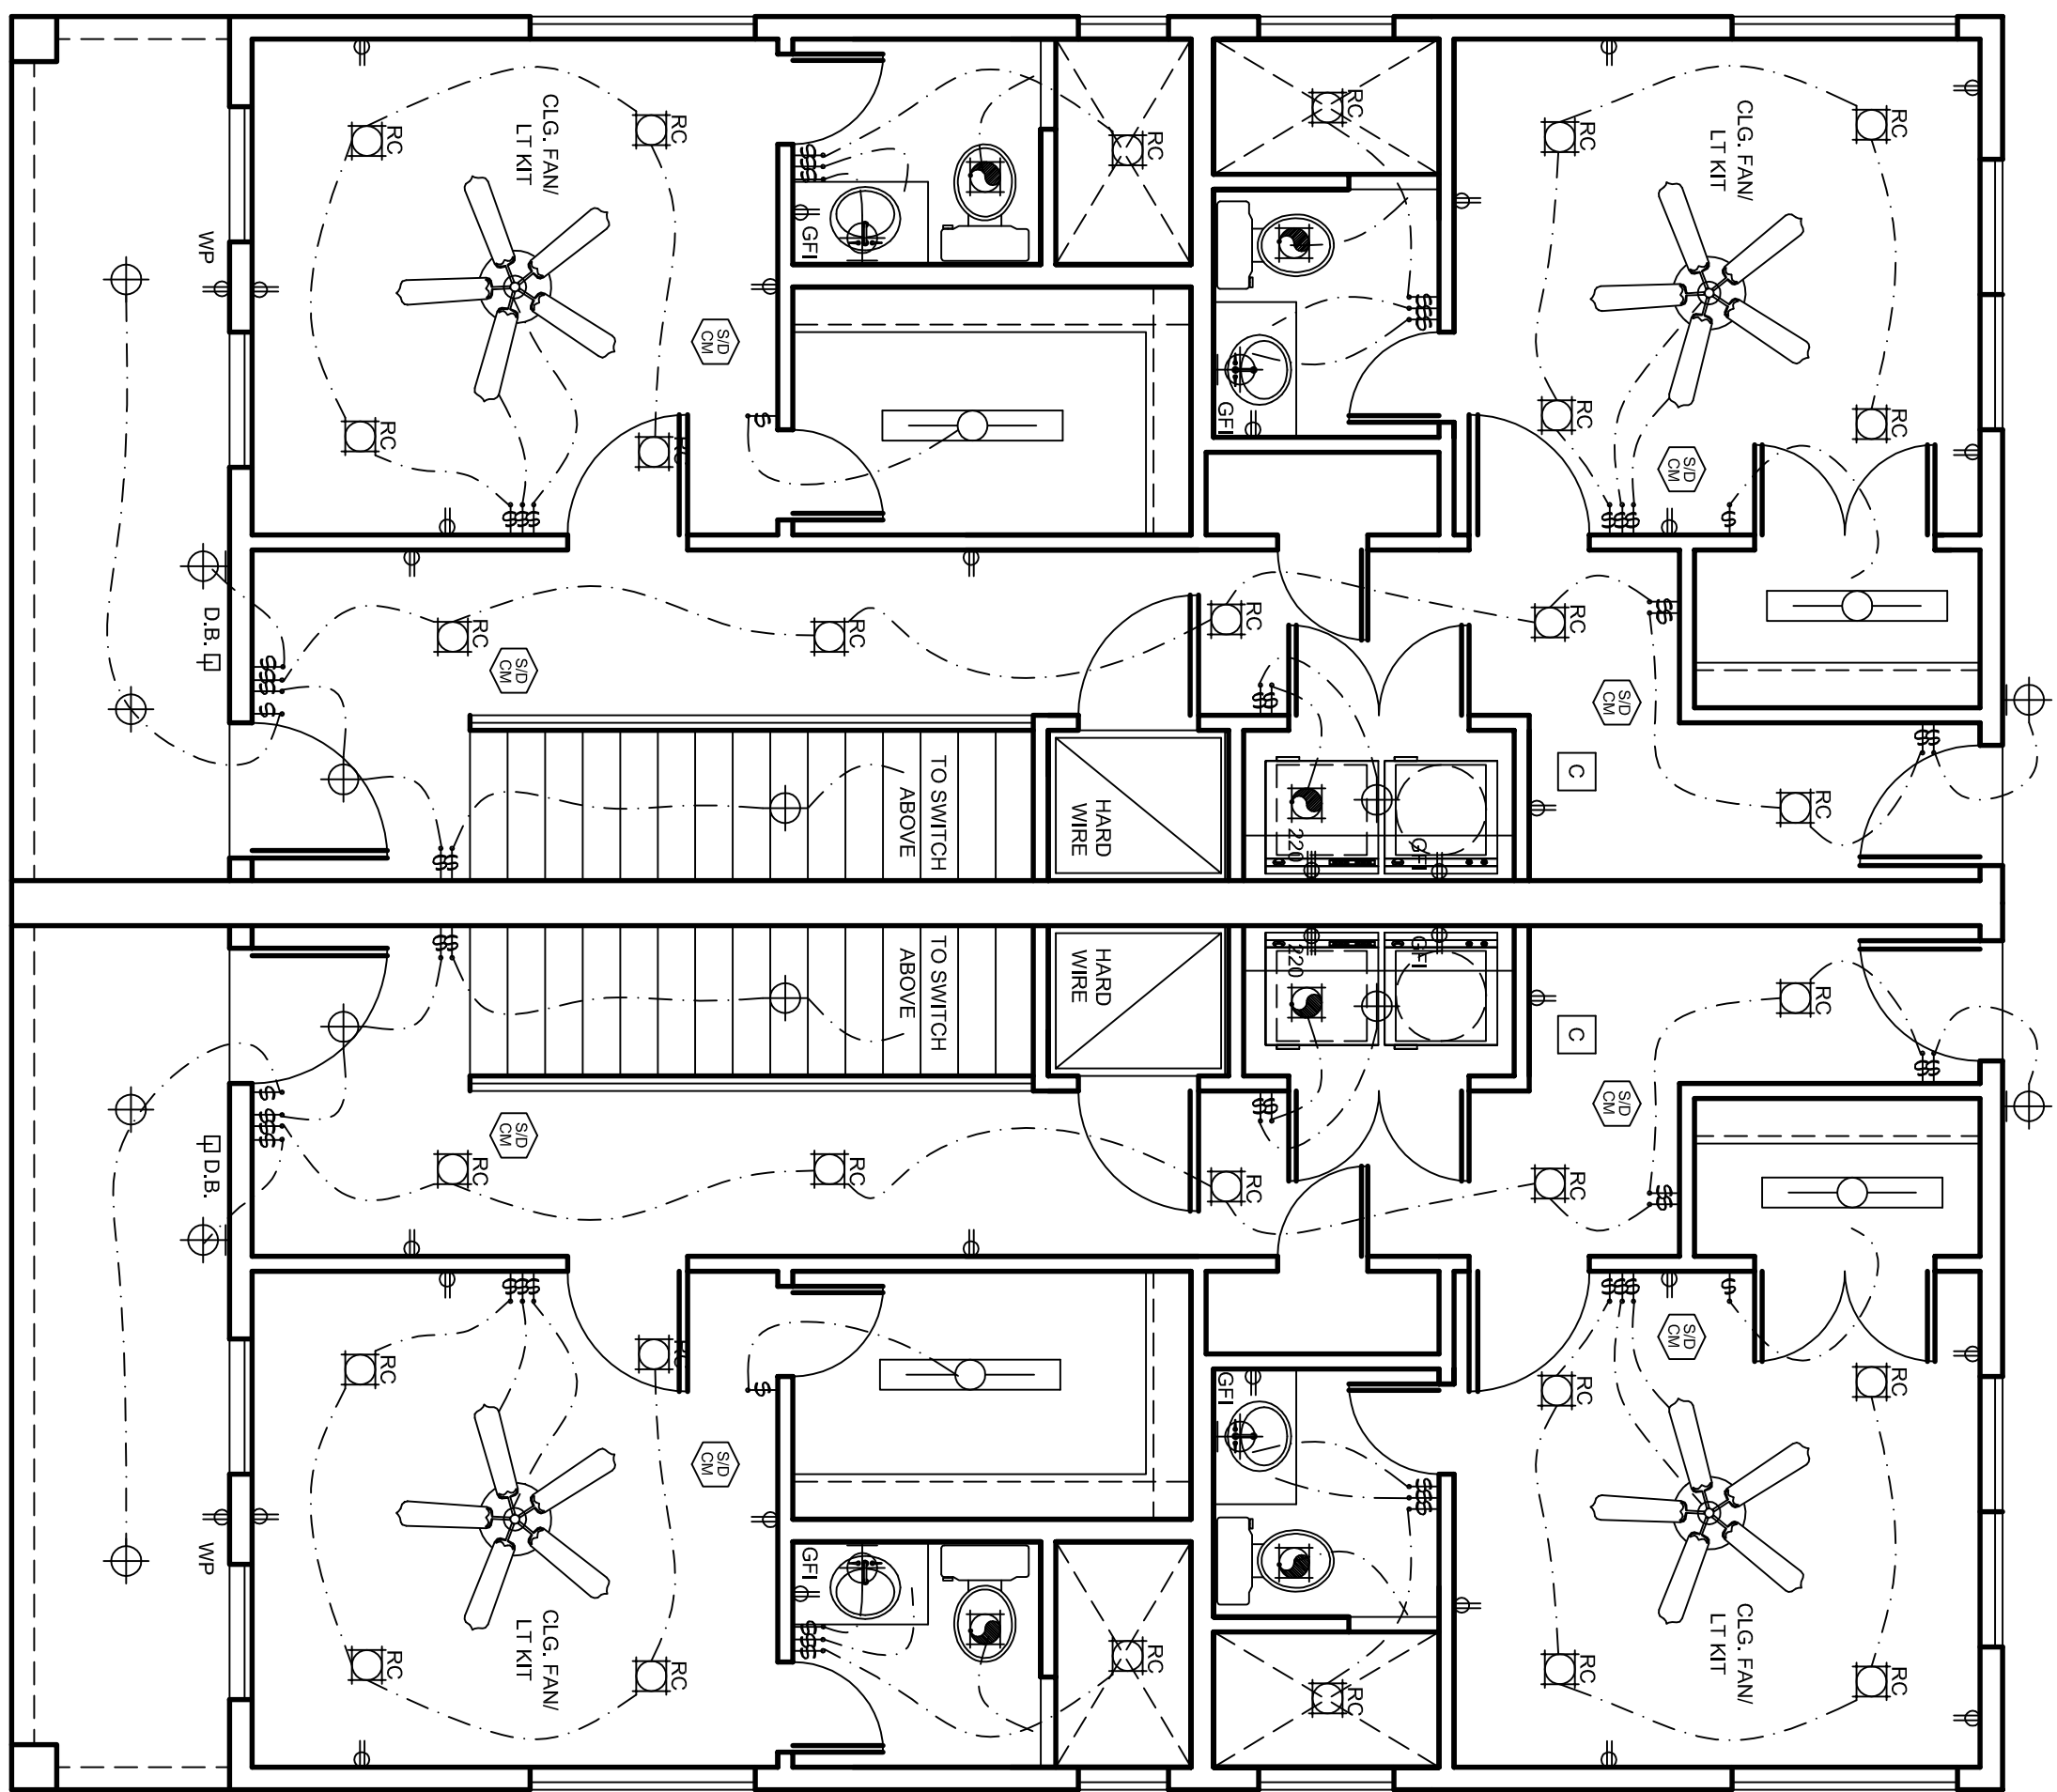

FIRST FLOOR ELECTRIC PLAN

SCALE: 1/4"=1'-0"

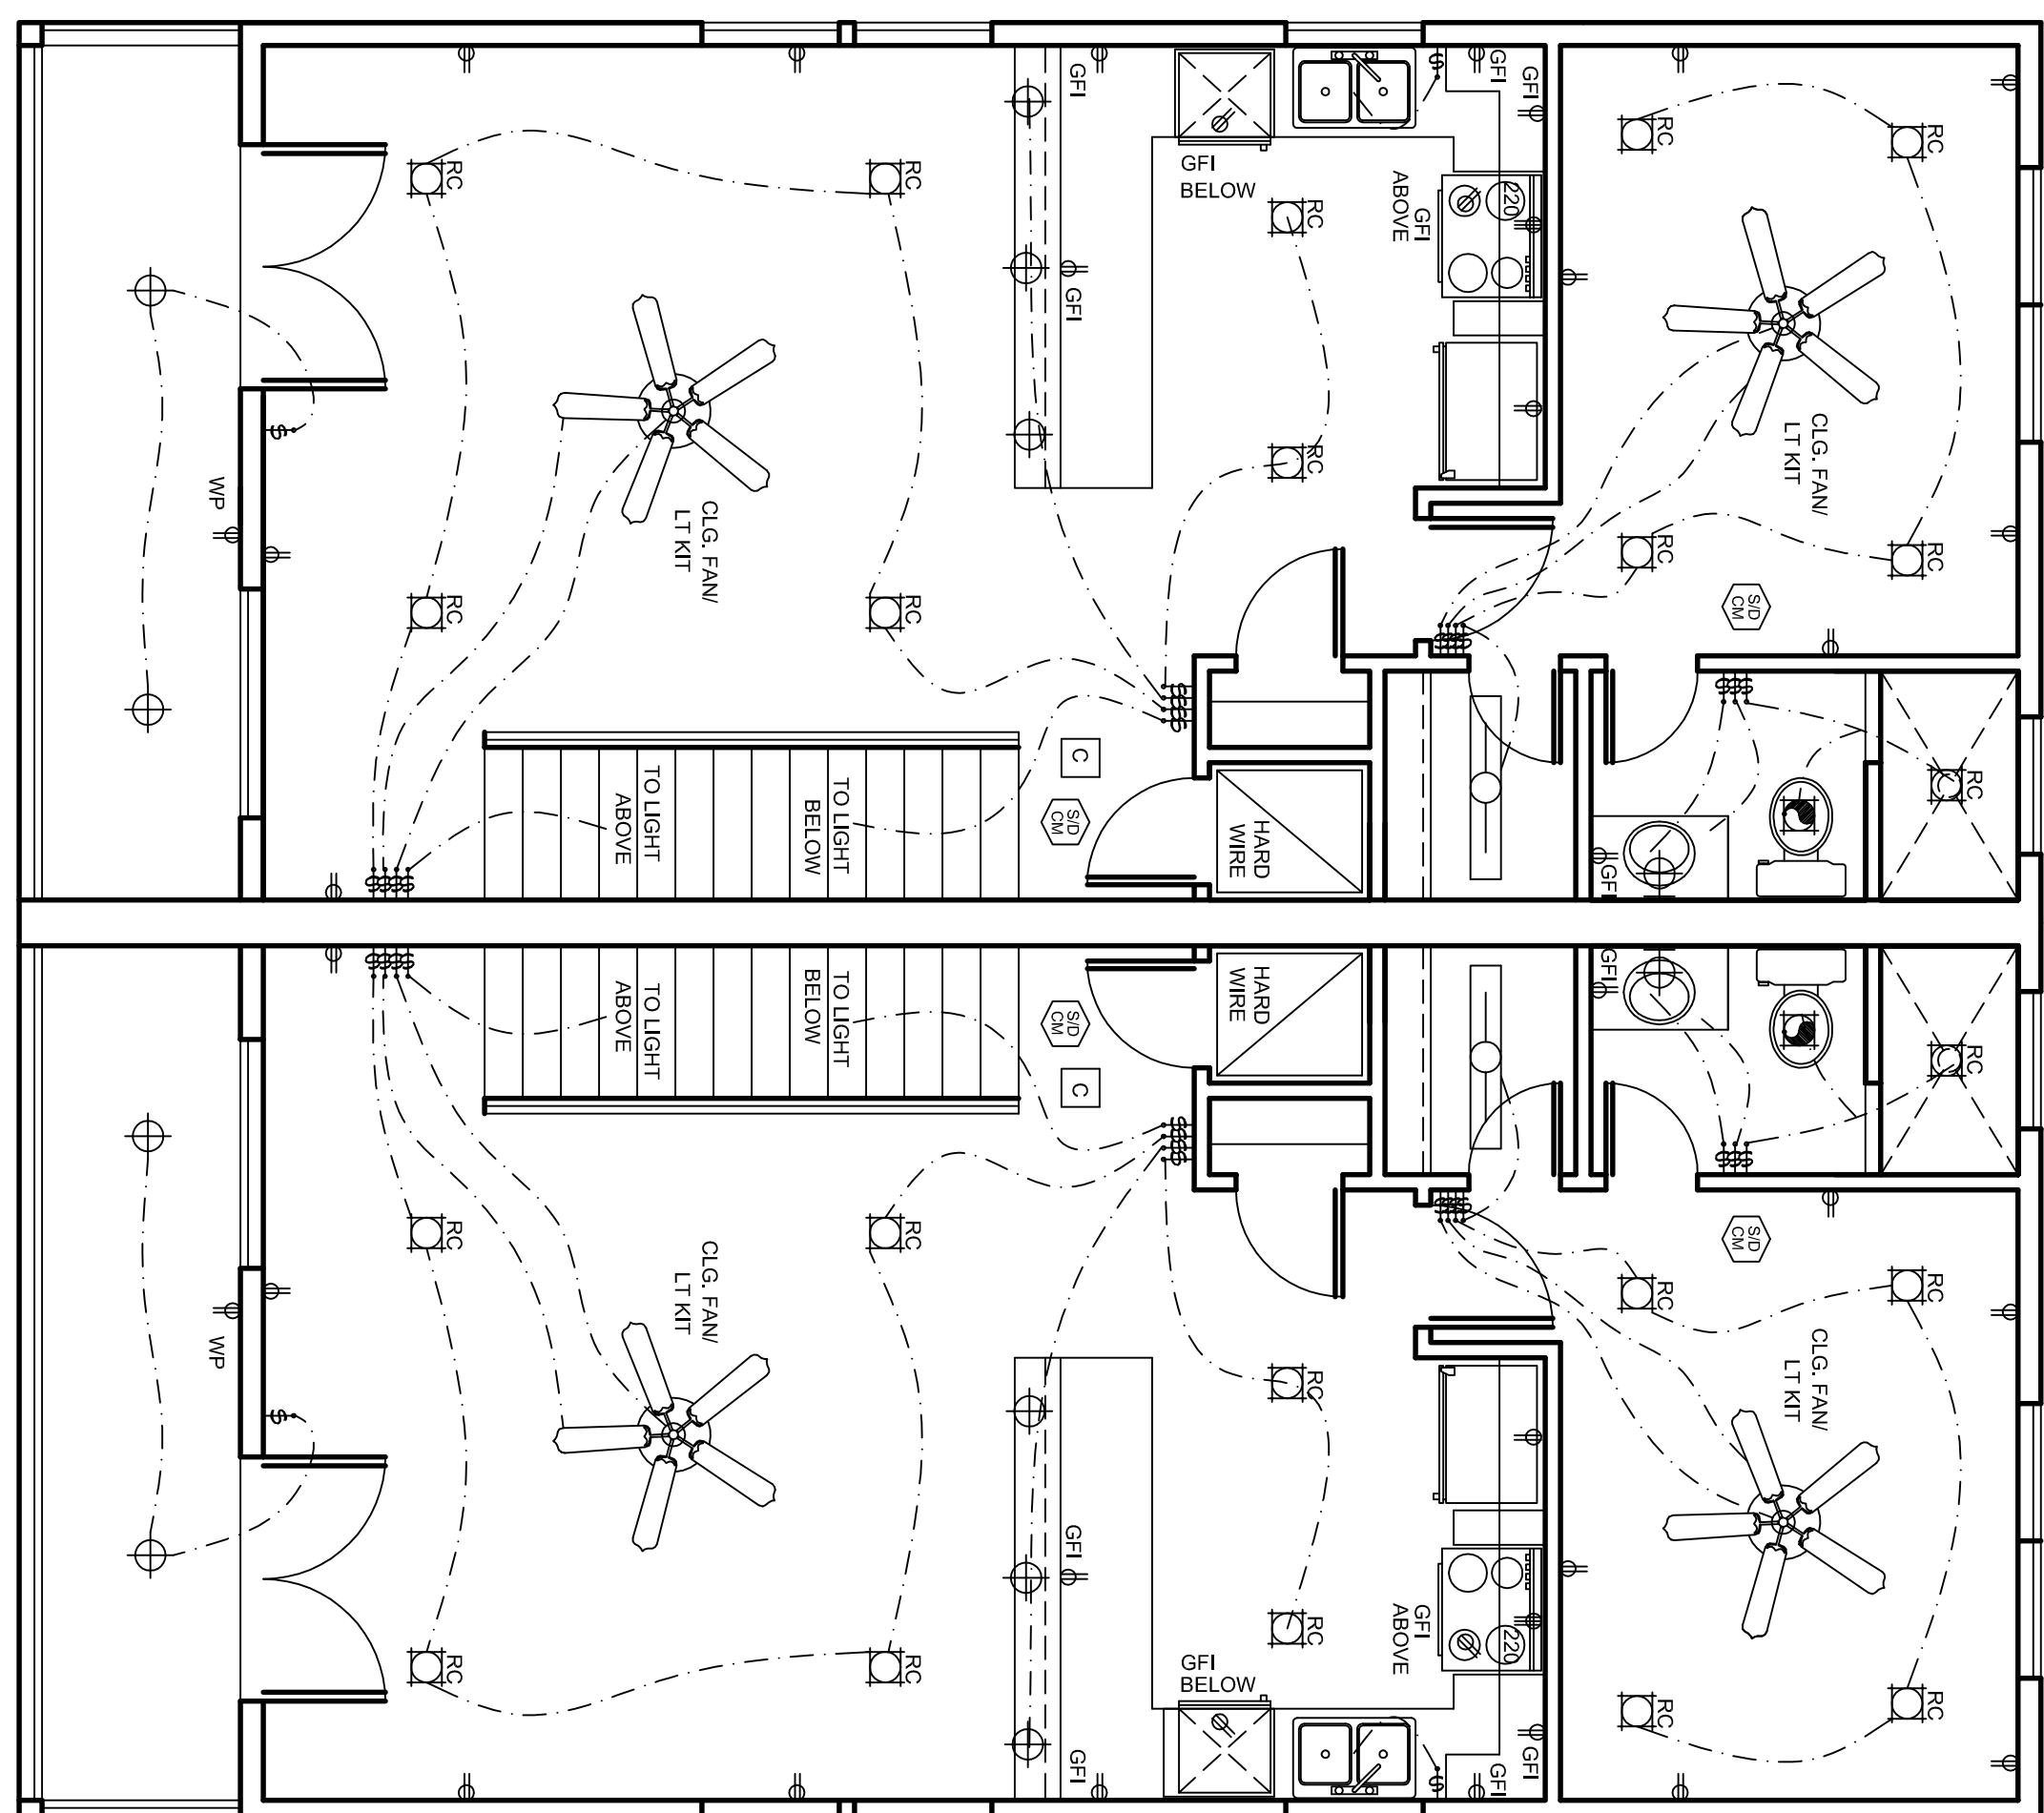

SECOND FLOOR ELECTRIC PLAN


SCALE: 1/4"=1'-0"


LOT:	BLK:	
ADDRESS:		
SUBDIVISION:		
CITY:		
COUNTY:		
STATE:	TX	
SCALE:	1/4"	

GOLDEN STAR ROCK INVESTMENTS

Doug Herron.com
Residential Designs
817-538-2910

EMAIL: dougplans@aol.com WEBSITE: dougherron.com

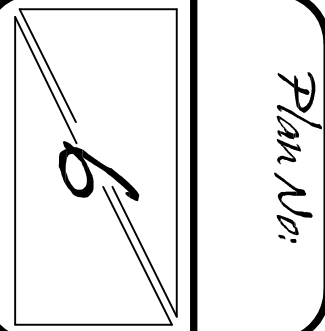

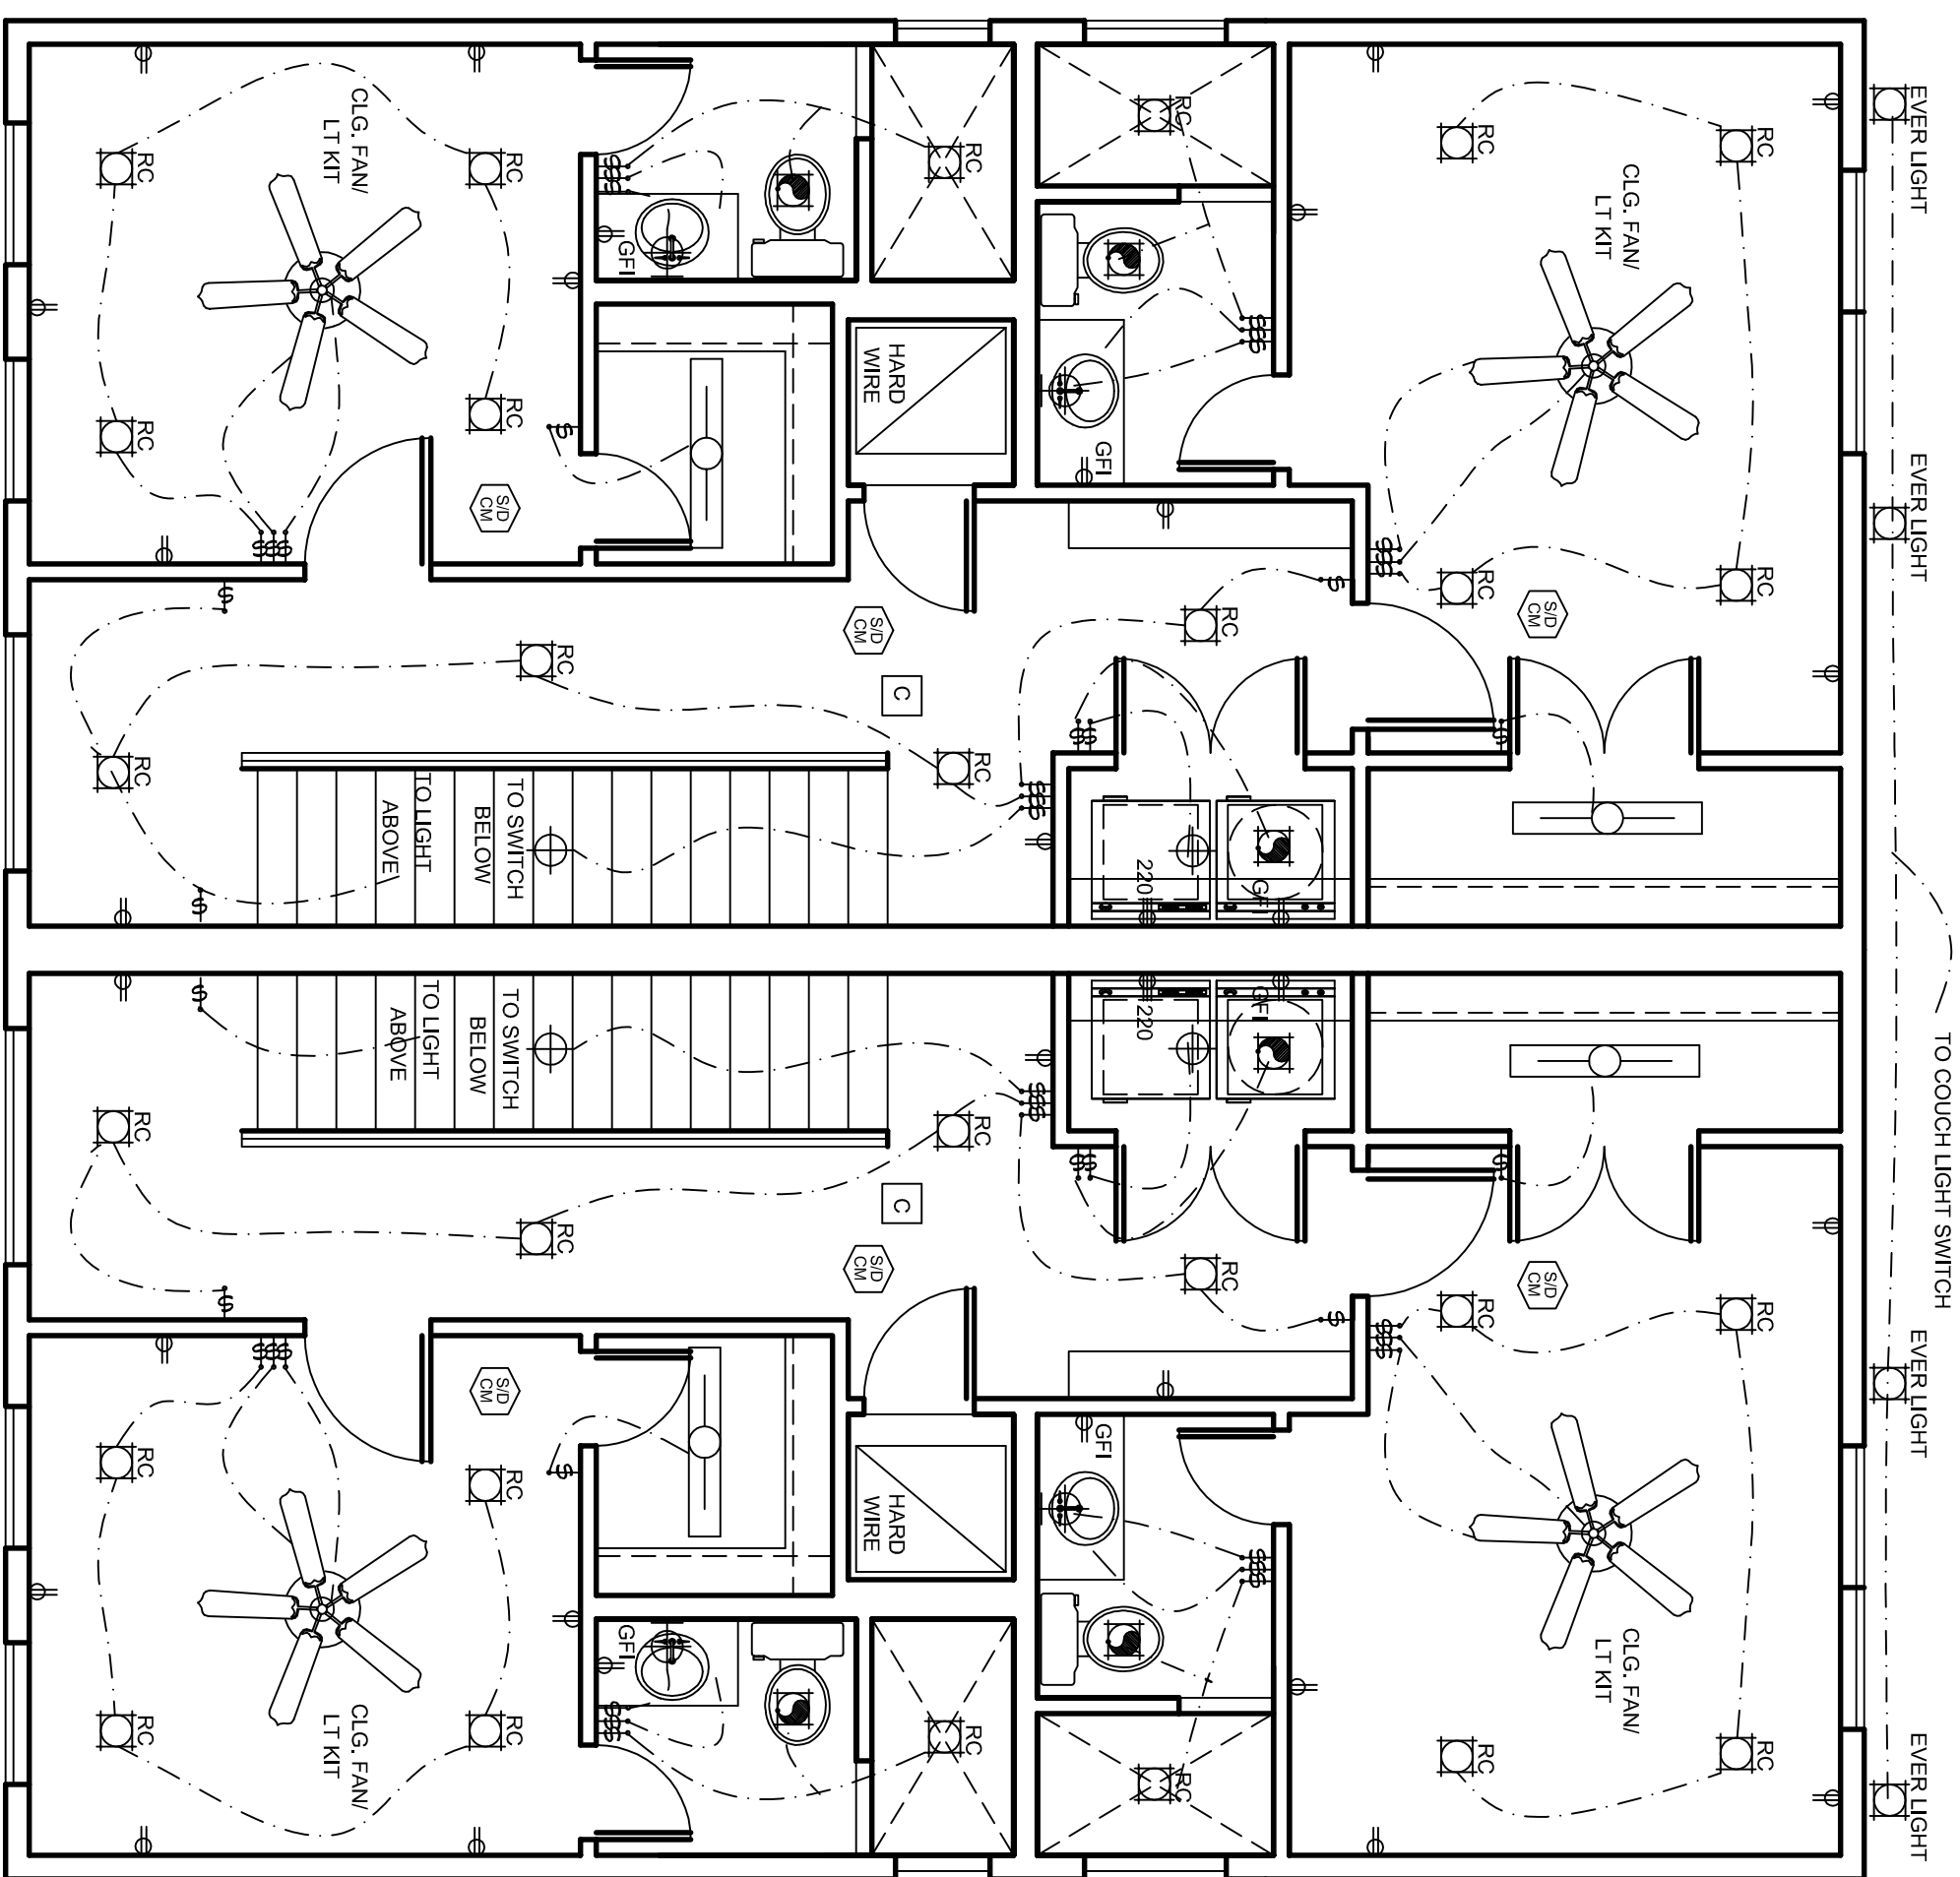


THIRD FLOOR ELECTRIC PLAN
SCALE: 1/4"=1'-0"

ELECTRICAL SCHEDULE

BLOCK FOR OPTIONAL CEILING FAN WITH LIGHT KIT

- RECESSED INCANDESCENT
- RECESSED SPOT
- CEILING MOUNTED FIXTURE
- WALL MOUNTED FIXTURE/COACH LIGHT
- UNDER CABINET FLOURESCENT
- OVERHEAD PULL CHAIN
- EXHAUST FAN WITH LIGHT
- EXHAUST FAN
- DOUBLE FLOOD LIGHTS
- 2 BULB OR 4 BULB FLOURESCENT
- SWITCH
- SWITCH WITH DIMMER
- 110-VOLT OUTLET
- 220-VOLT OUTLET
- WEATHERPROOFED, GROUNDED 110-VOLT
- GROUNDED 110-VOLT OUTLET
- 1/2 HOT 110-VOLT OUTLET
- CEILING/ UNDER ABOVE 110-VOLT OUTLET
- FLOOR 110-VOLT OUTLET AND OR UNDER
- PHONE
- TV CABLE
- SMOKE DETECTOR/ CARBON MONOXIDE
- INTERCOM/SPEAKER
- MASTER INTERCOM/SPEAKER
- ELECTRIC EYE
- SECURITY KEY PAD
- DOORBELL
- CHIME
- GAS HOOK-UP
- HOSE BIBB
- ELECTRICAL PANELS

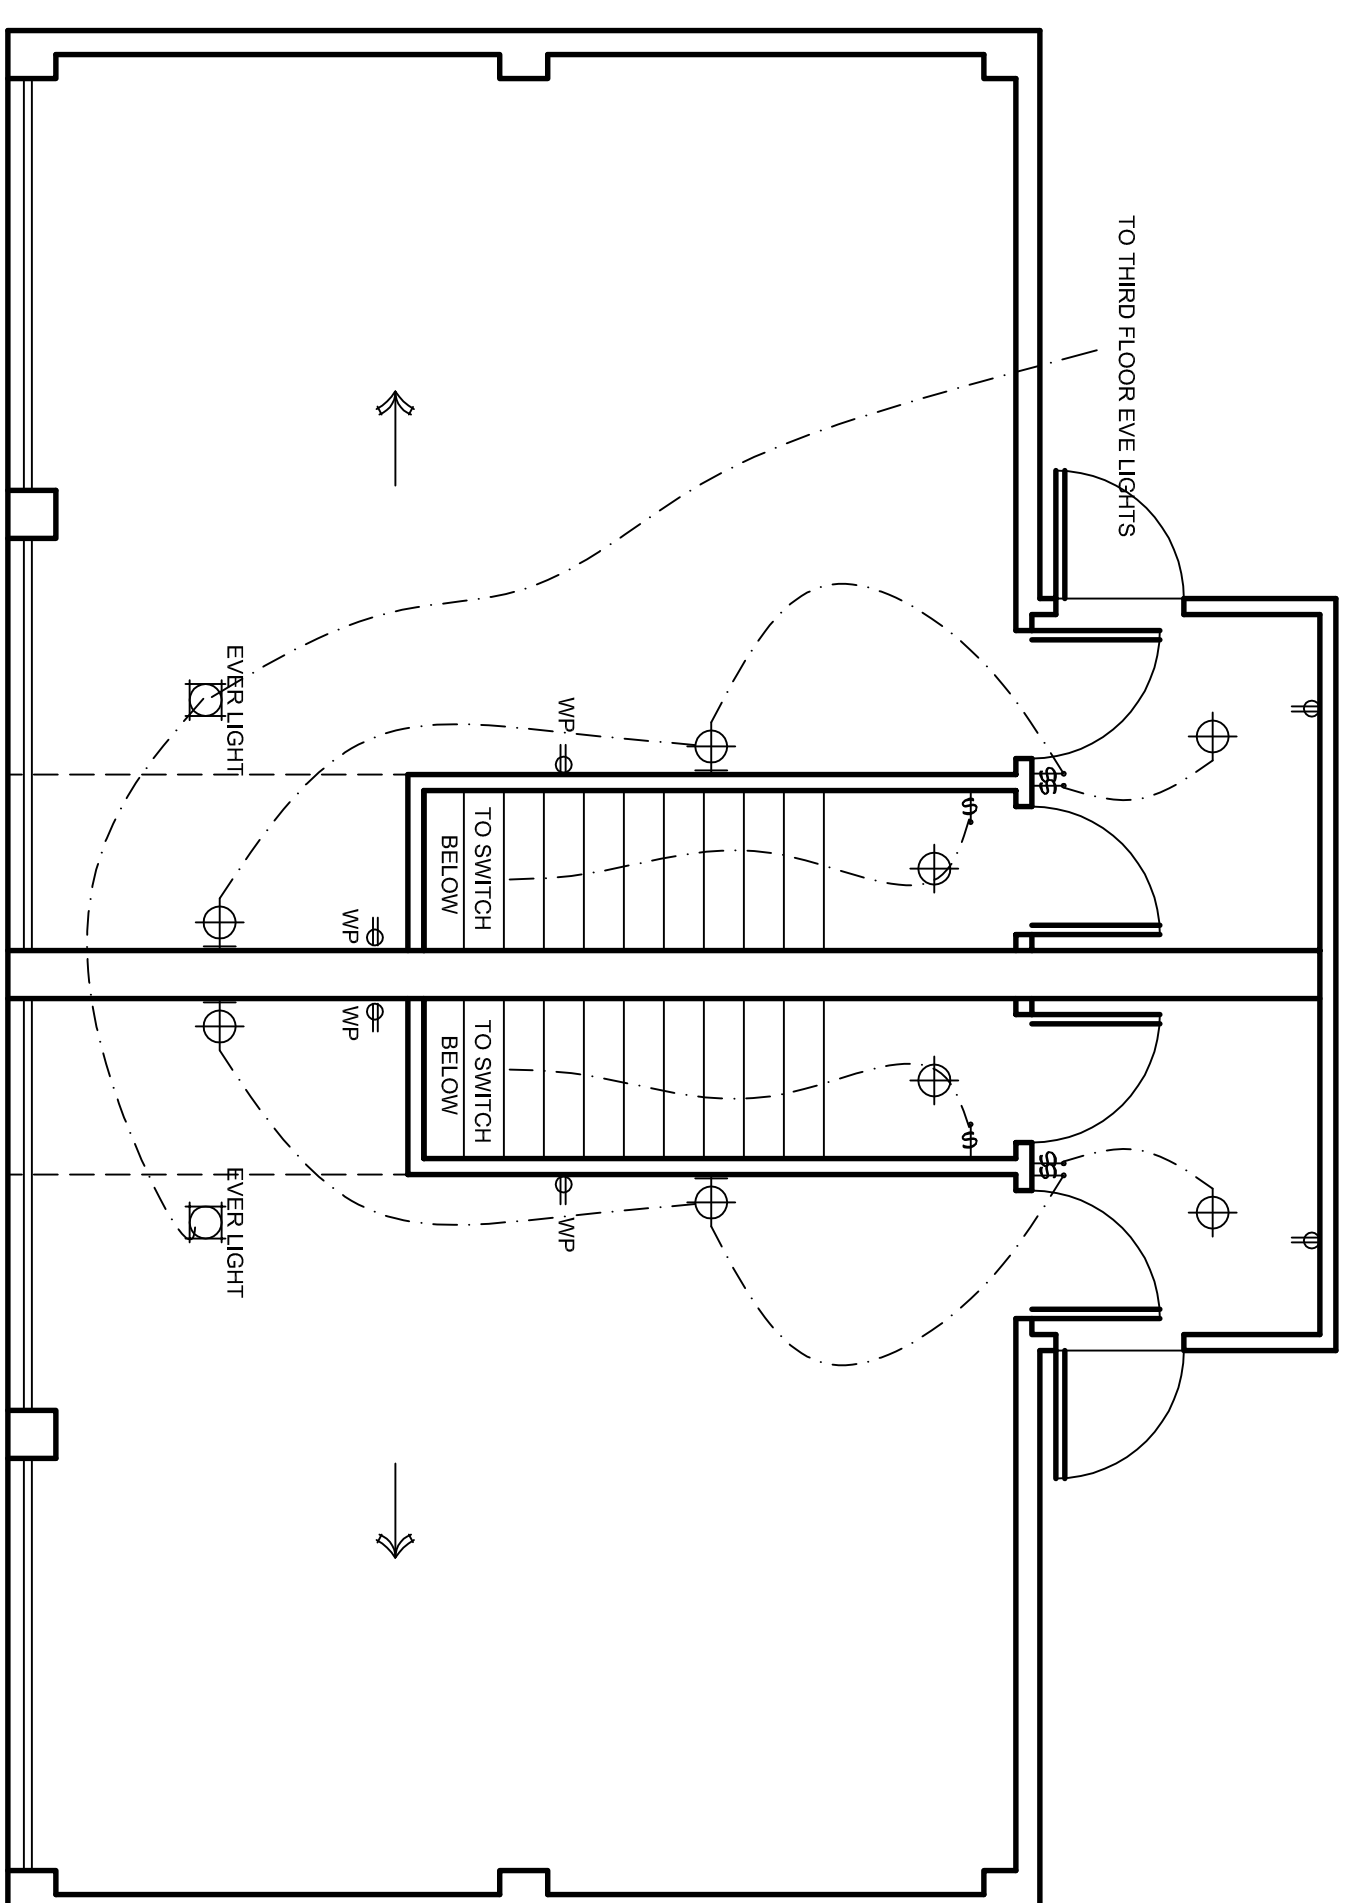

FOURTH FLOOR ELECTRIC PLAN
SCALE: 1/4"=1'-0"

Doug Herron.com
Residential Designs
817-538-2910

EMAIL: dougsplans@aol.com WEBSITE: dougherron.com

LOT:	BLK:
ADDRESS:	
SUBDIVISION:	
CITY:	
COUNTY:	
STATE:	TX
SCALE:	1/4"

GOLDEN STAR ROCK INVESTMENTS

Plan No. 7