



NOTE: ATTACHED 3D RENDERINGS MAY DIFFER FROM 2D CONSTRUCTION DRAWINGS, (REFER TO 2D ELEVATION DRAWINGS FOR CONSTRUCTION DETAILS)

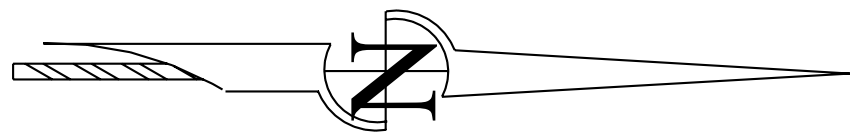



LOT 1, BLOCK 27
WESTCLIFF ADDITION
CITY OF FORT WORTH
TARRANT COUNTY, TEXAS

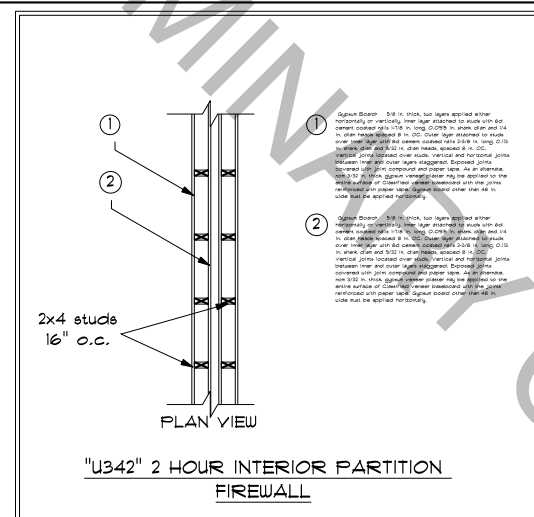

A horizontal number line with tick marks at 0, 1, 2, and 4. The segments between the tick marks are shaded as follows: the segment from 0 to 1 is black, from 1 to 2 is white, from 2 to 4 is black, and the segment starting at 4 is white.

D & A Development
3501 Plymouth Ave.


GRAND
HOME DESIGNS

CONTACT:
114 Sproles Dr. Ste. 103
Fort Worth
817.696.0520
info@grandhomedesigns.com

RAWN BY: Dale G. & Morgan
START DATE: 05/23/2026

PLAN NUMBER:
6-6240-CON-2026


PAGE: 2/6

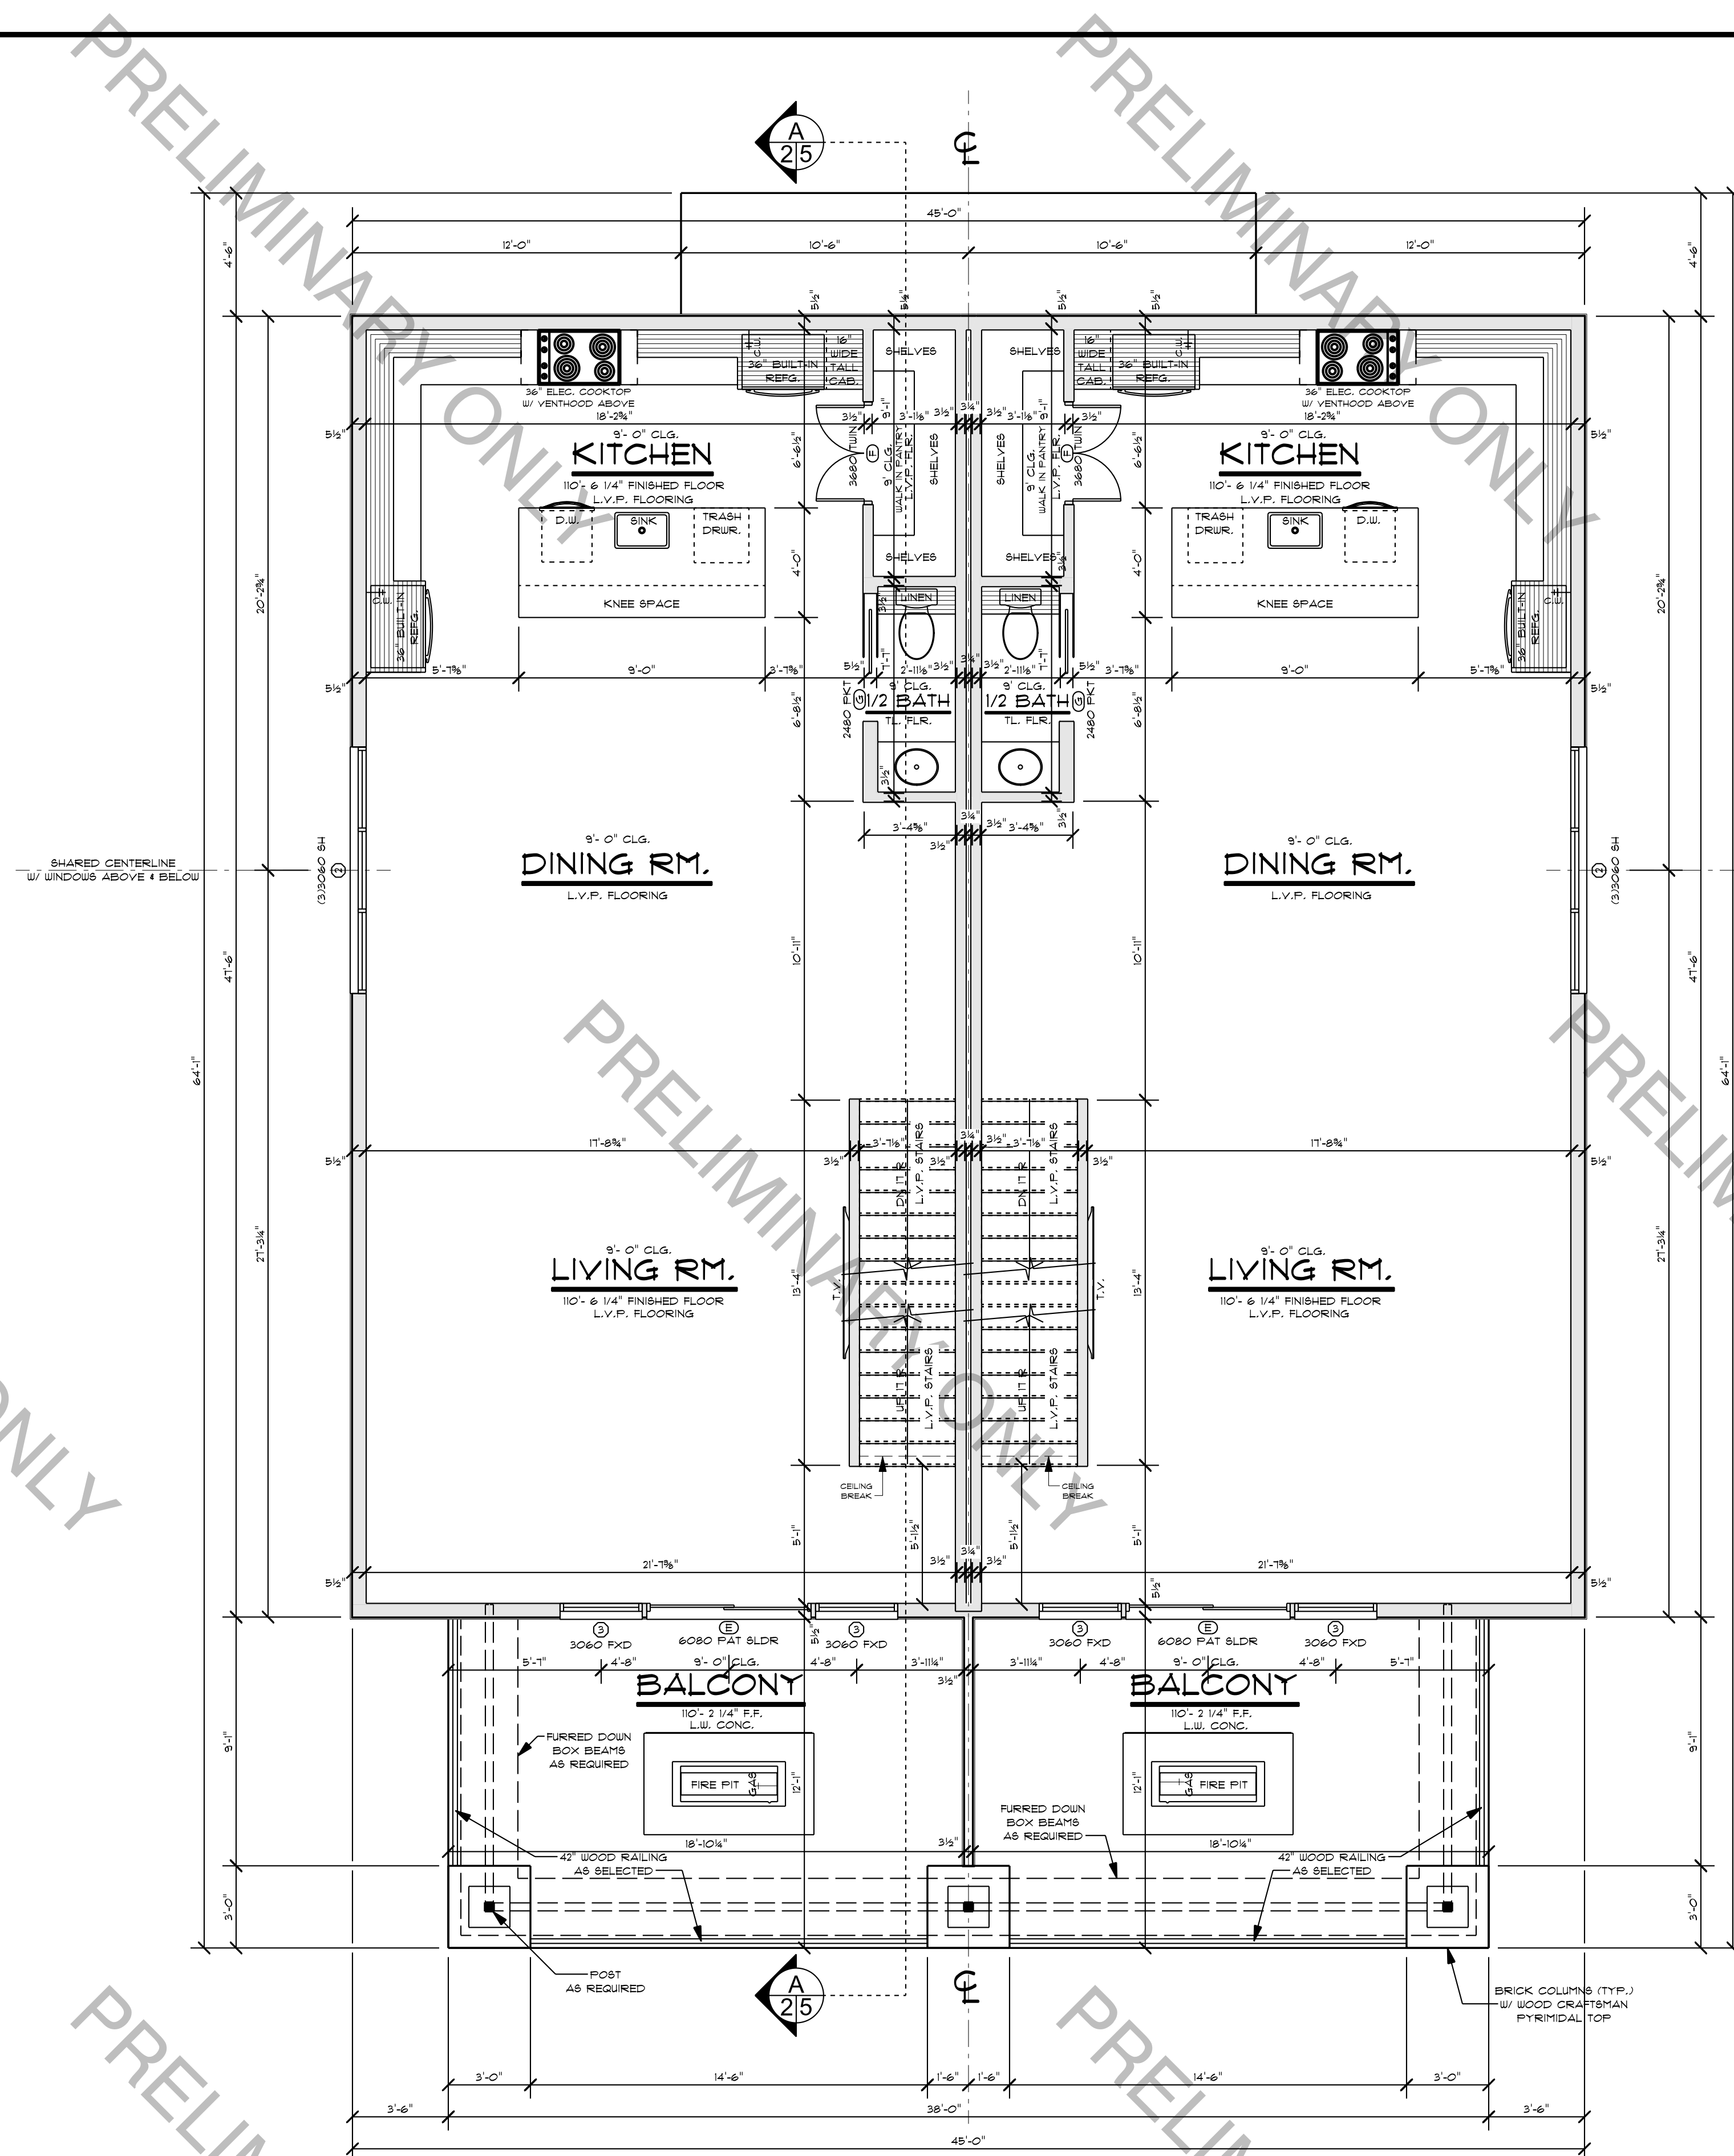

2ND FLOOR PLAN

SCALE: 1/4" = 1'-0"

WINDOW SCHEDULE				
OPENING ID	PRODUCT CODE	SIZE	HEADER POSITION	COUNT
1	(2)3060 SH	6'-0" x 8'-0" 8'-0"		6
2	(3)3060 SH	9'-0" x 6'-0" 8'-0"		2
3	3060 FXD	3'-0" x 6'-0" 8'-0"		4
4	2040 SH	2'-0" x 4'-0" 6'-8"		4
5	(2)3050 SH	6'-0" x 5'-0" 6'-8"		6

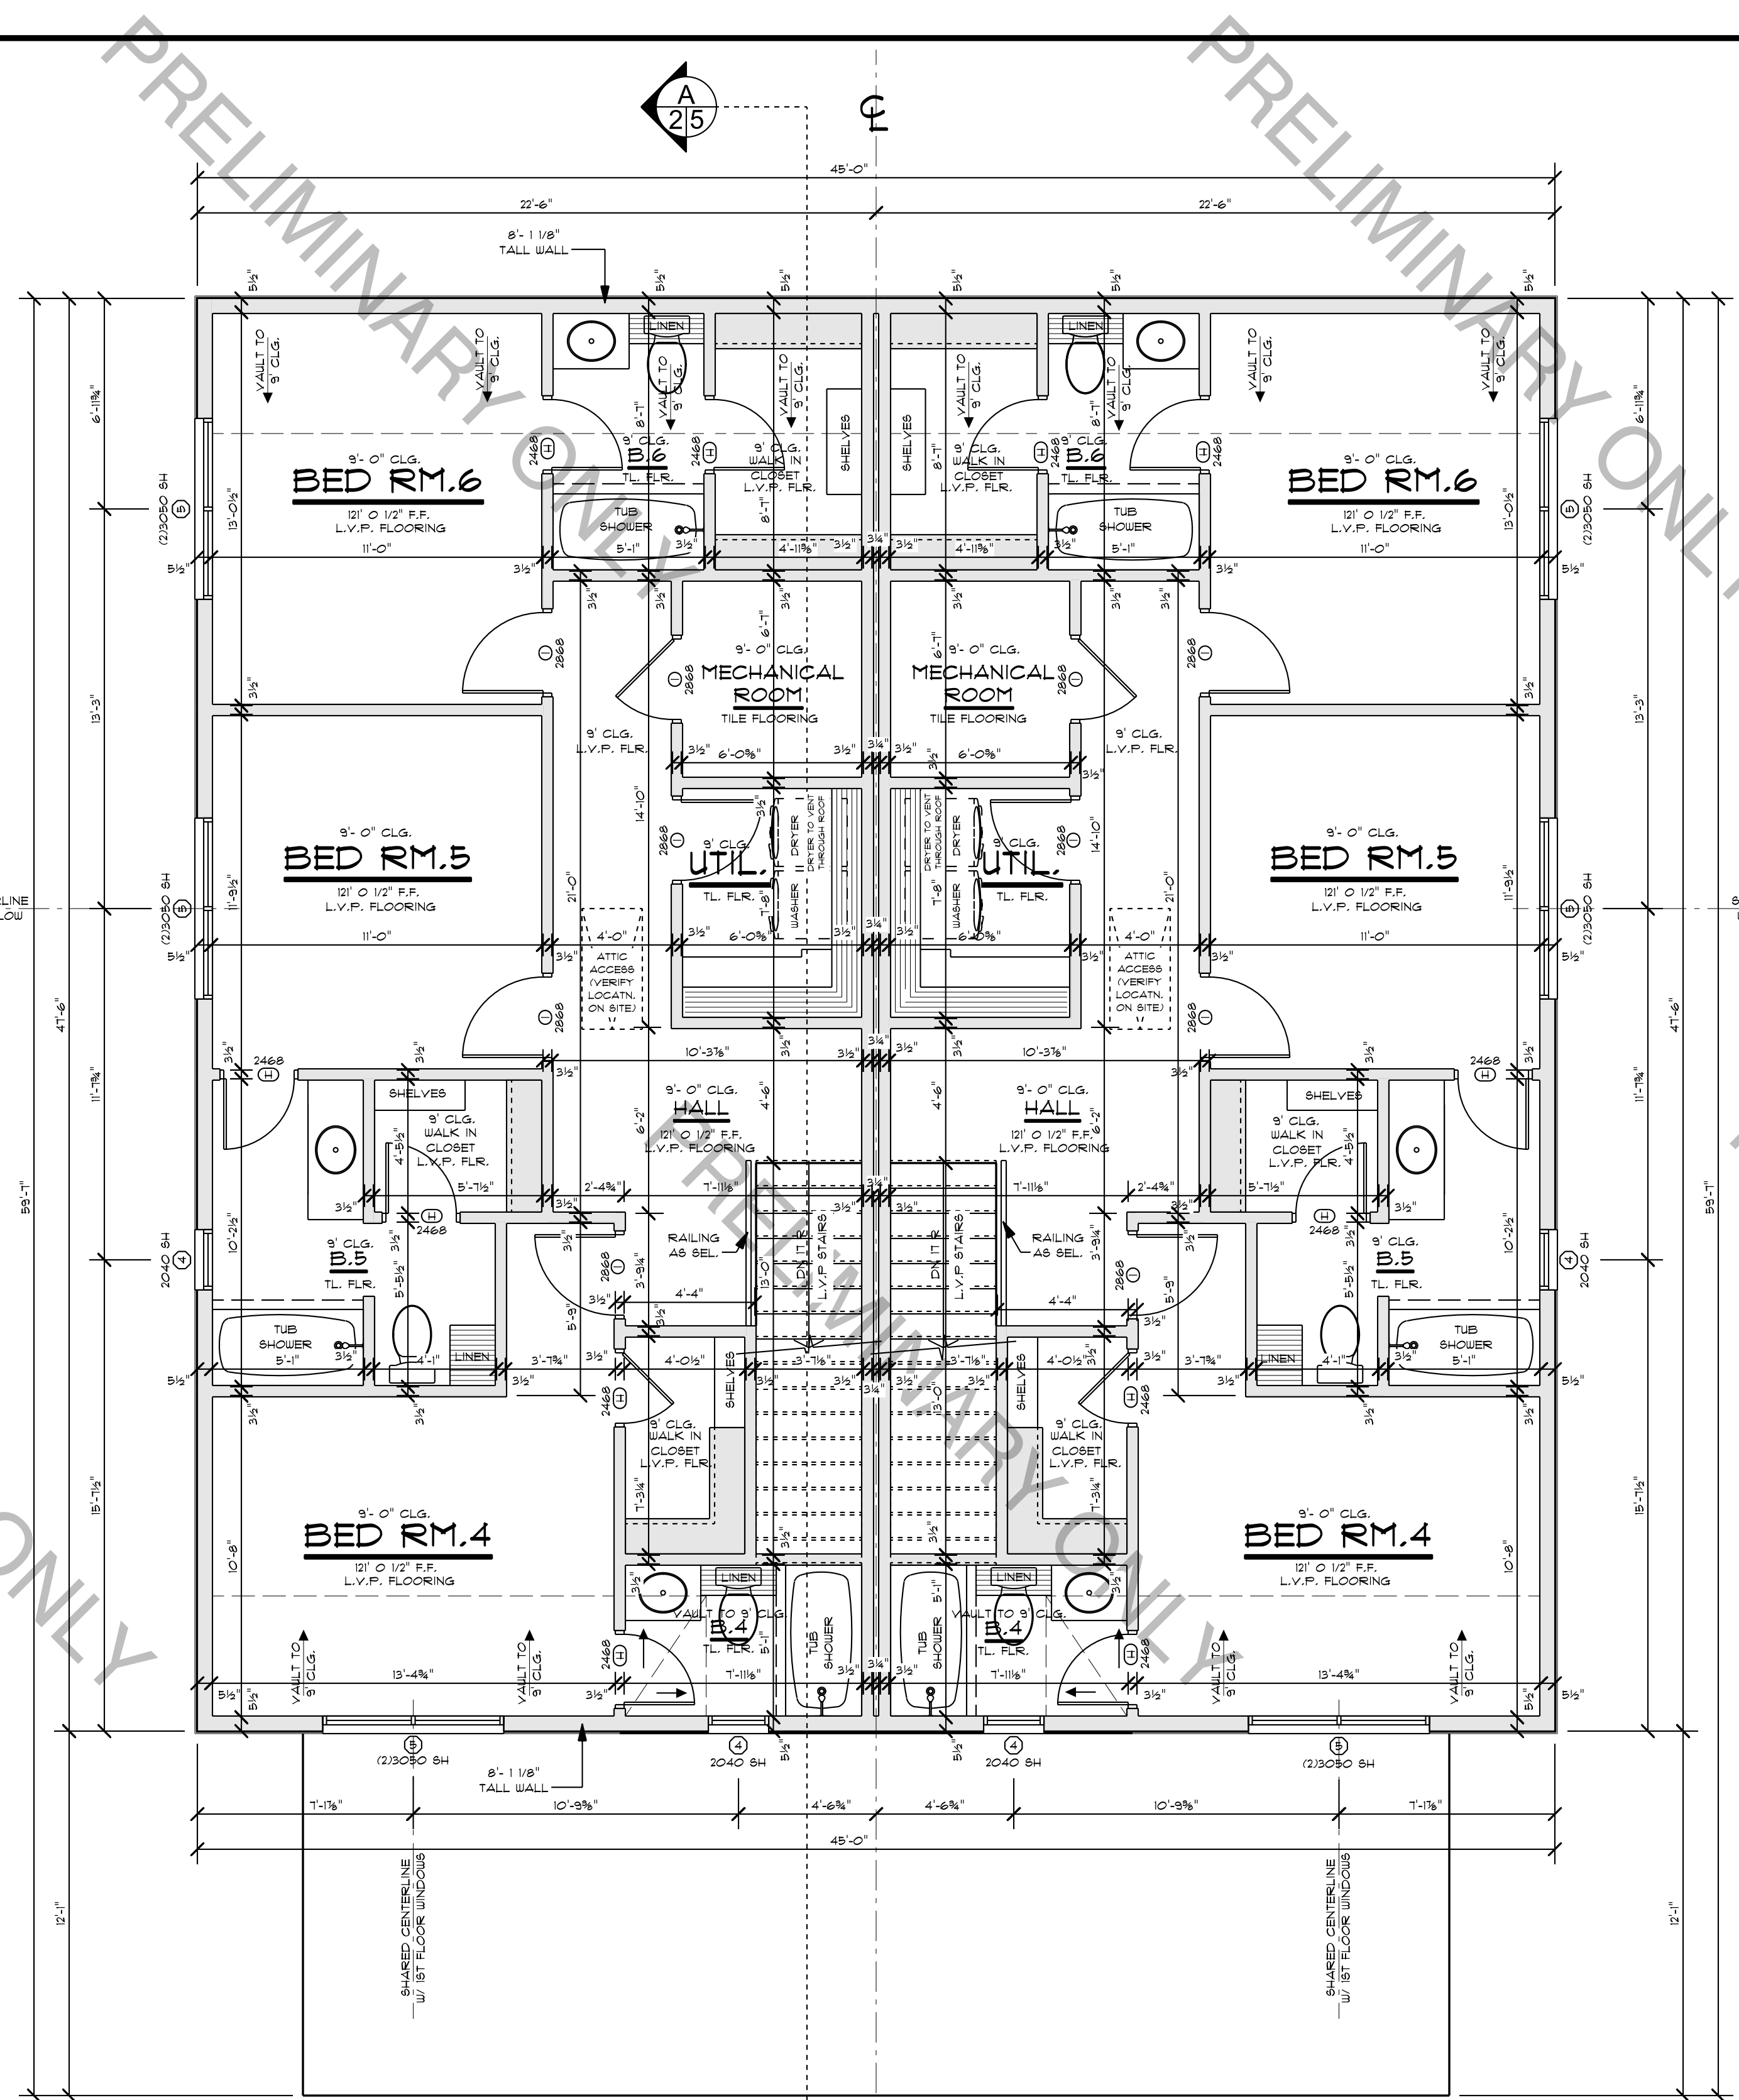

3RD FLOOR PLAN

SCALE: 1/4" = 1'-0"

DOOR SCHEDULE					
OPENING ID	PRODUCT CODE	SIZE	HINGE	REVERSED	COUNT
A	3680 CRAFT	3'-6" x 8'-0"	L	NO	1
A	3680 CRAFT	3'-6" x 8'-0"	R	NO	1
B	3080 CRAFT	3'-0" x 8'-0"	L	NO	1
B	3080 CRAFT	3'-0" x 8'-0"	R	NO	1
C	2480	2'-4" x 8'-0"	L	NO	1
C	2480	2'-4" x 8'-0"	R	NO	1
D	2880	2'-8" x 8'-0"	L	NO	3
D	2880	2'-8" x 8'-0"	R	NO	3
E	6080 FAT SLDR	6'-0" x 8'-0"	RN	NO	2
F	3680 TWIN	3'-6" x 8'-0"	LR	NO	2
G	2480 FKT	2'-4" x 8'-0"	N	NO	2
H	2468	2'-4" x 6'-8"	L	NO	6
H	2468	2'-4" x 6'-8"	R	NO	6
I	2868	2'-8" x 6'-8"	L	NO	5
I	2868	2'-8" x 6'-8"	R	NO	5



REAR ELEVATION



SCALE: 1/4" = 1'-0"

NOTE:
- DRAWINGS INDICATE
16" FLOOR SYSTEM W/
1-1/8" DECKING

RIGHT ELEVATION

SCALE: 1/4" = 1'-0"

NOTE:
- DRAWINGS INDICATE
16" FLOOR SYSTEM W/
1-1/8" DECKING

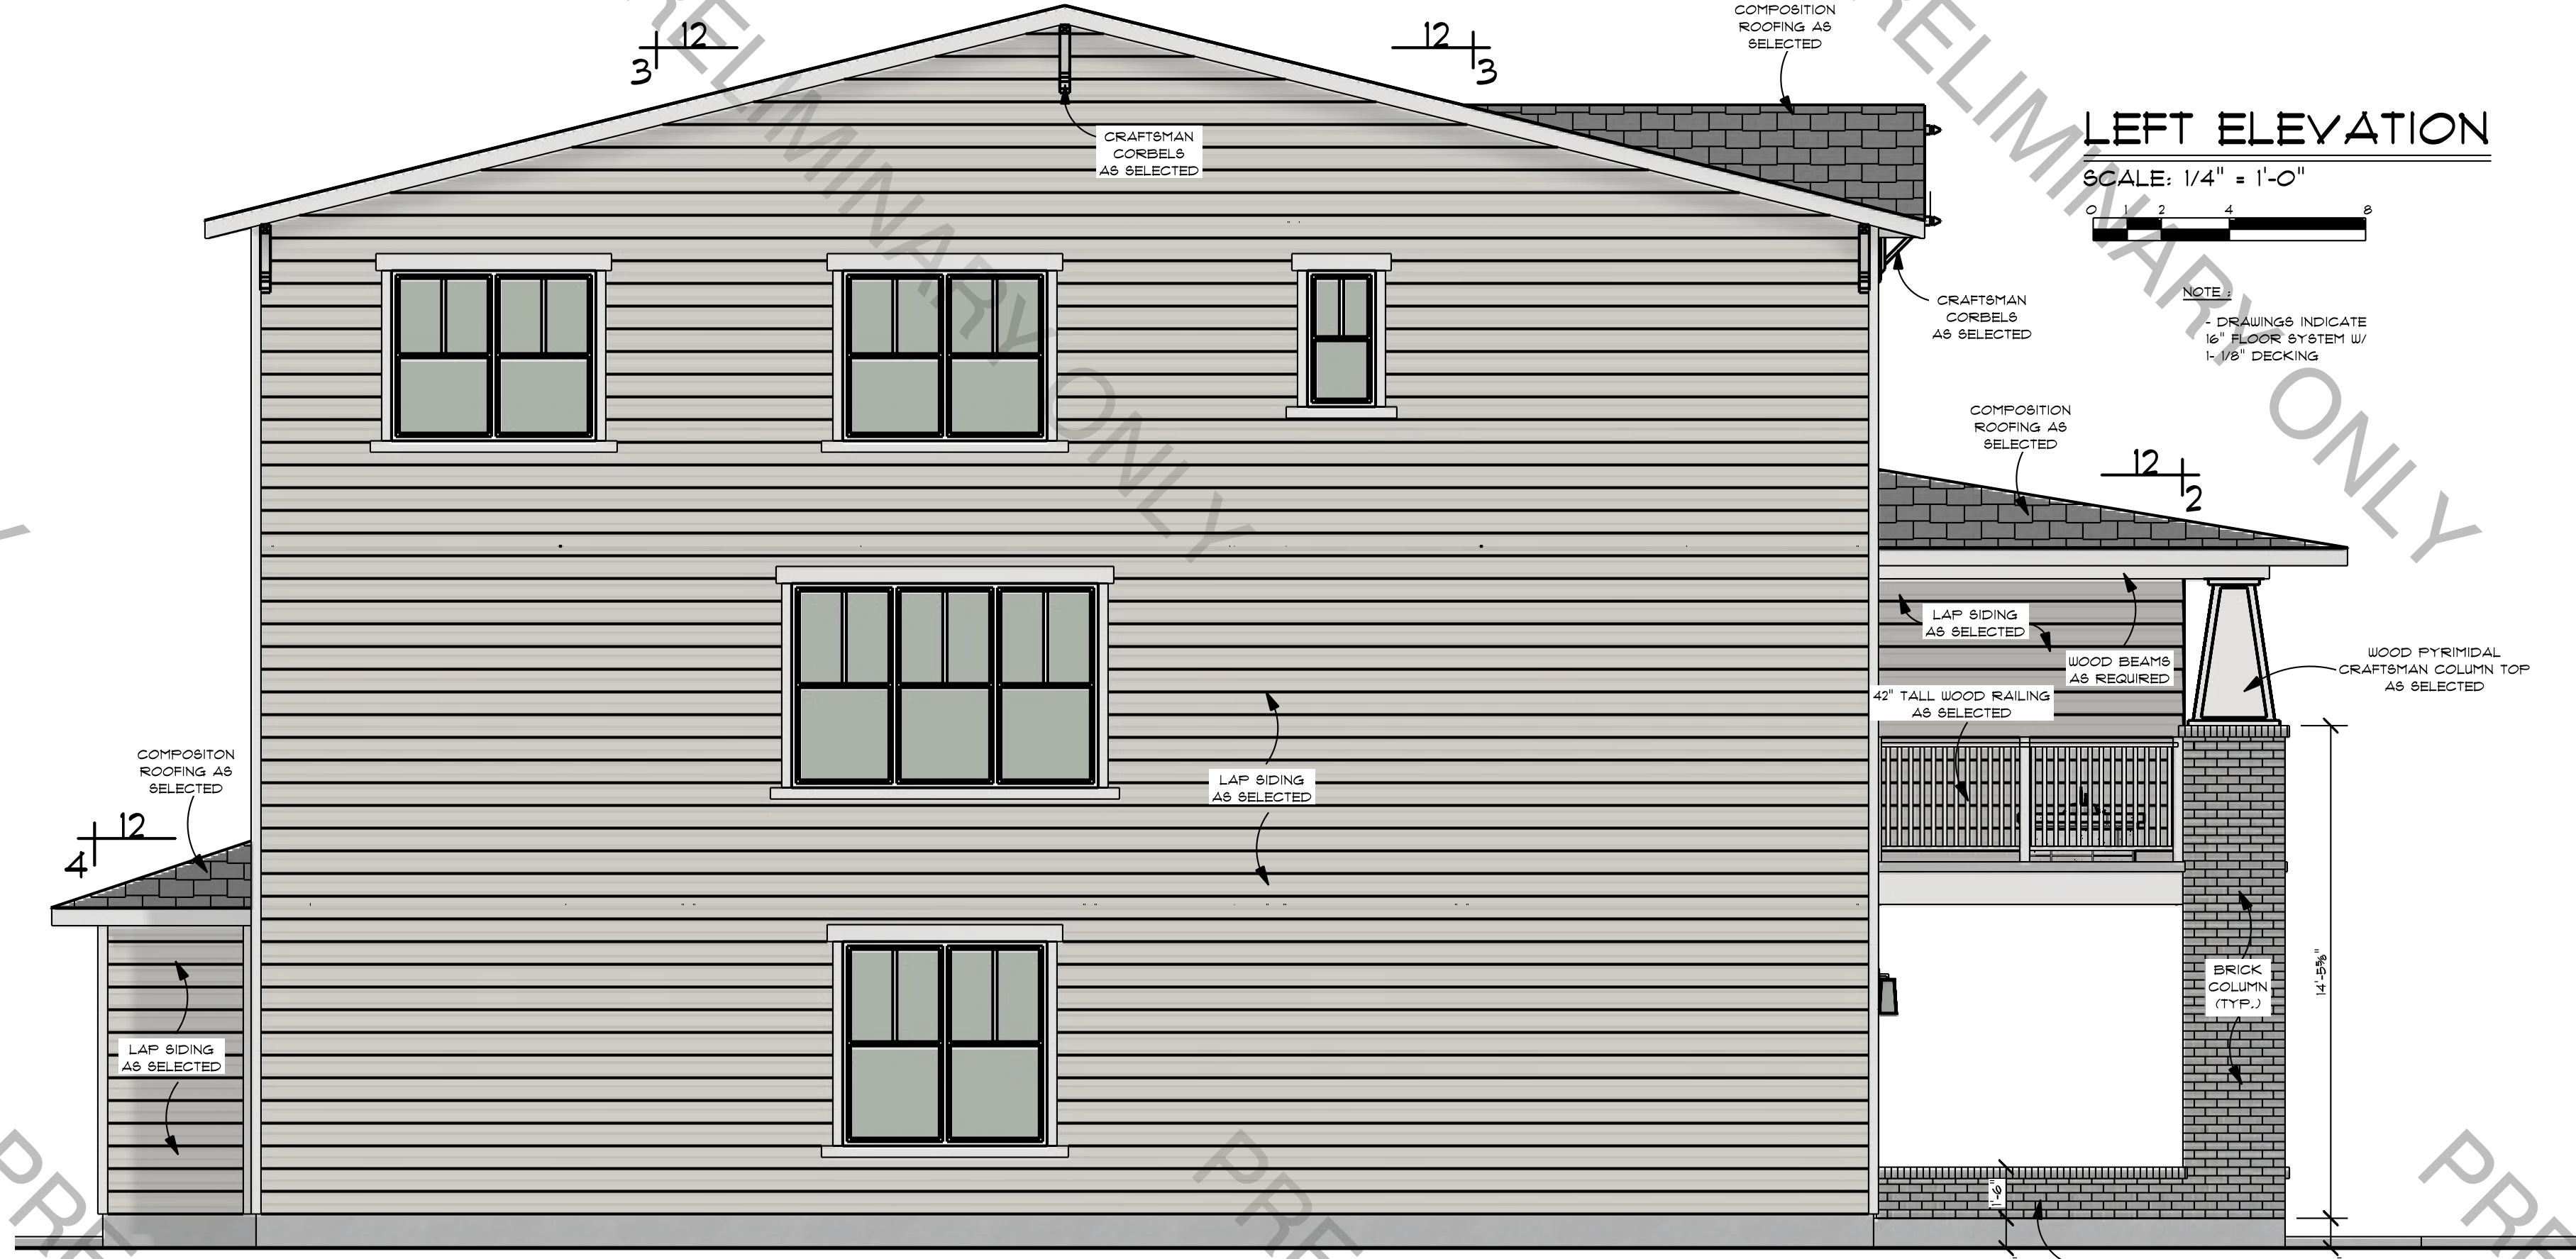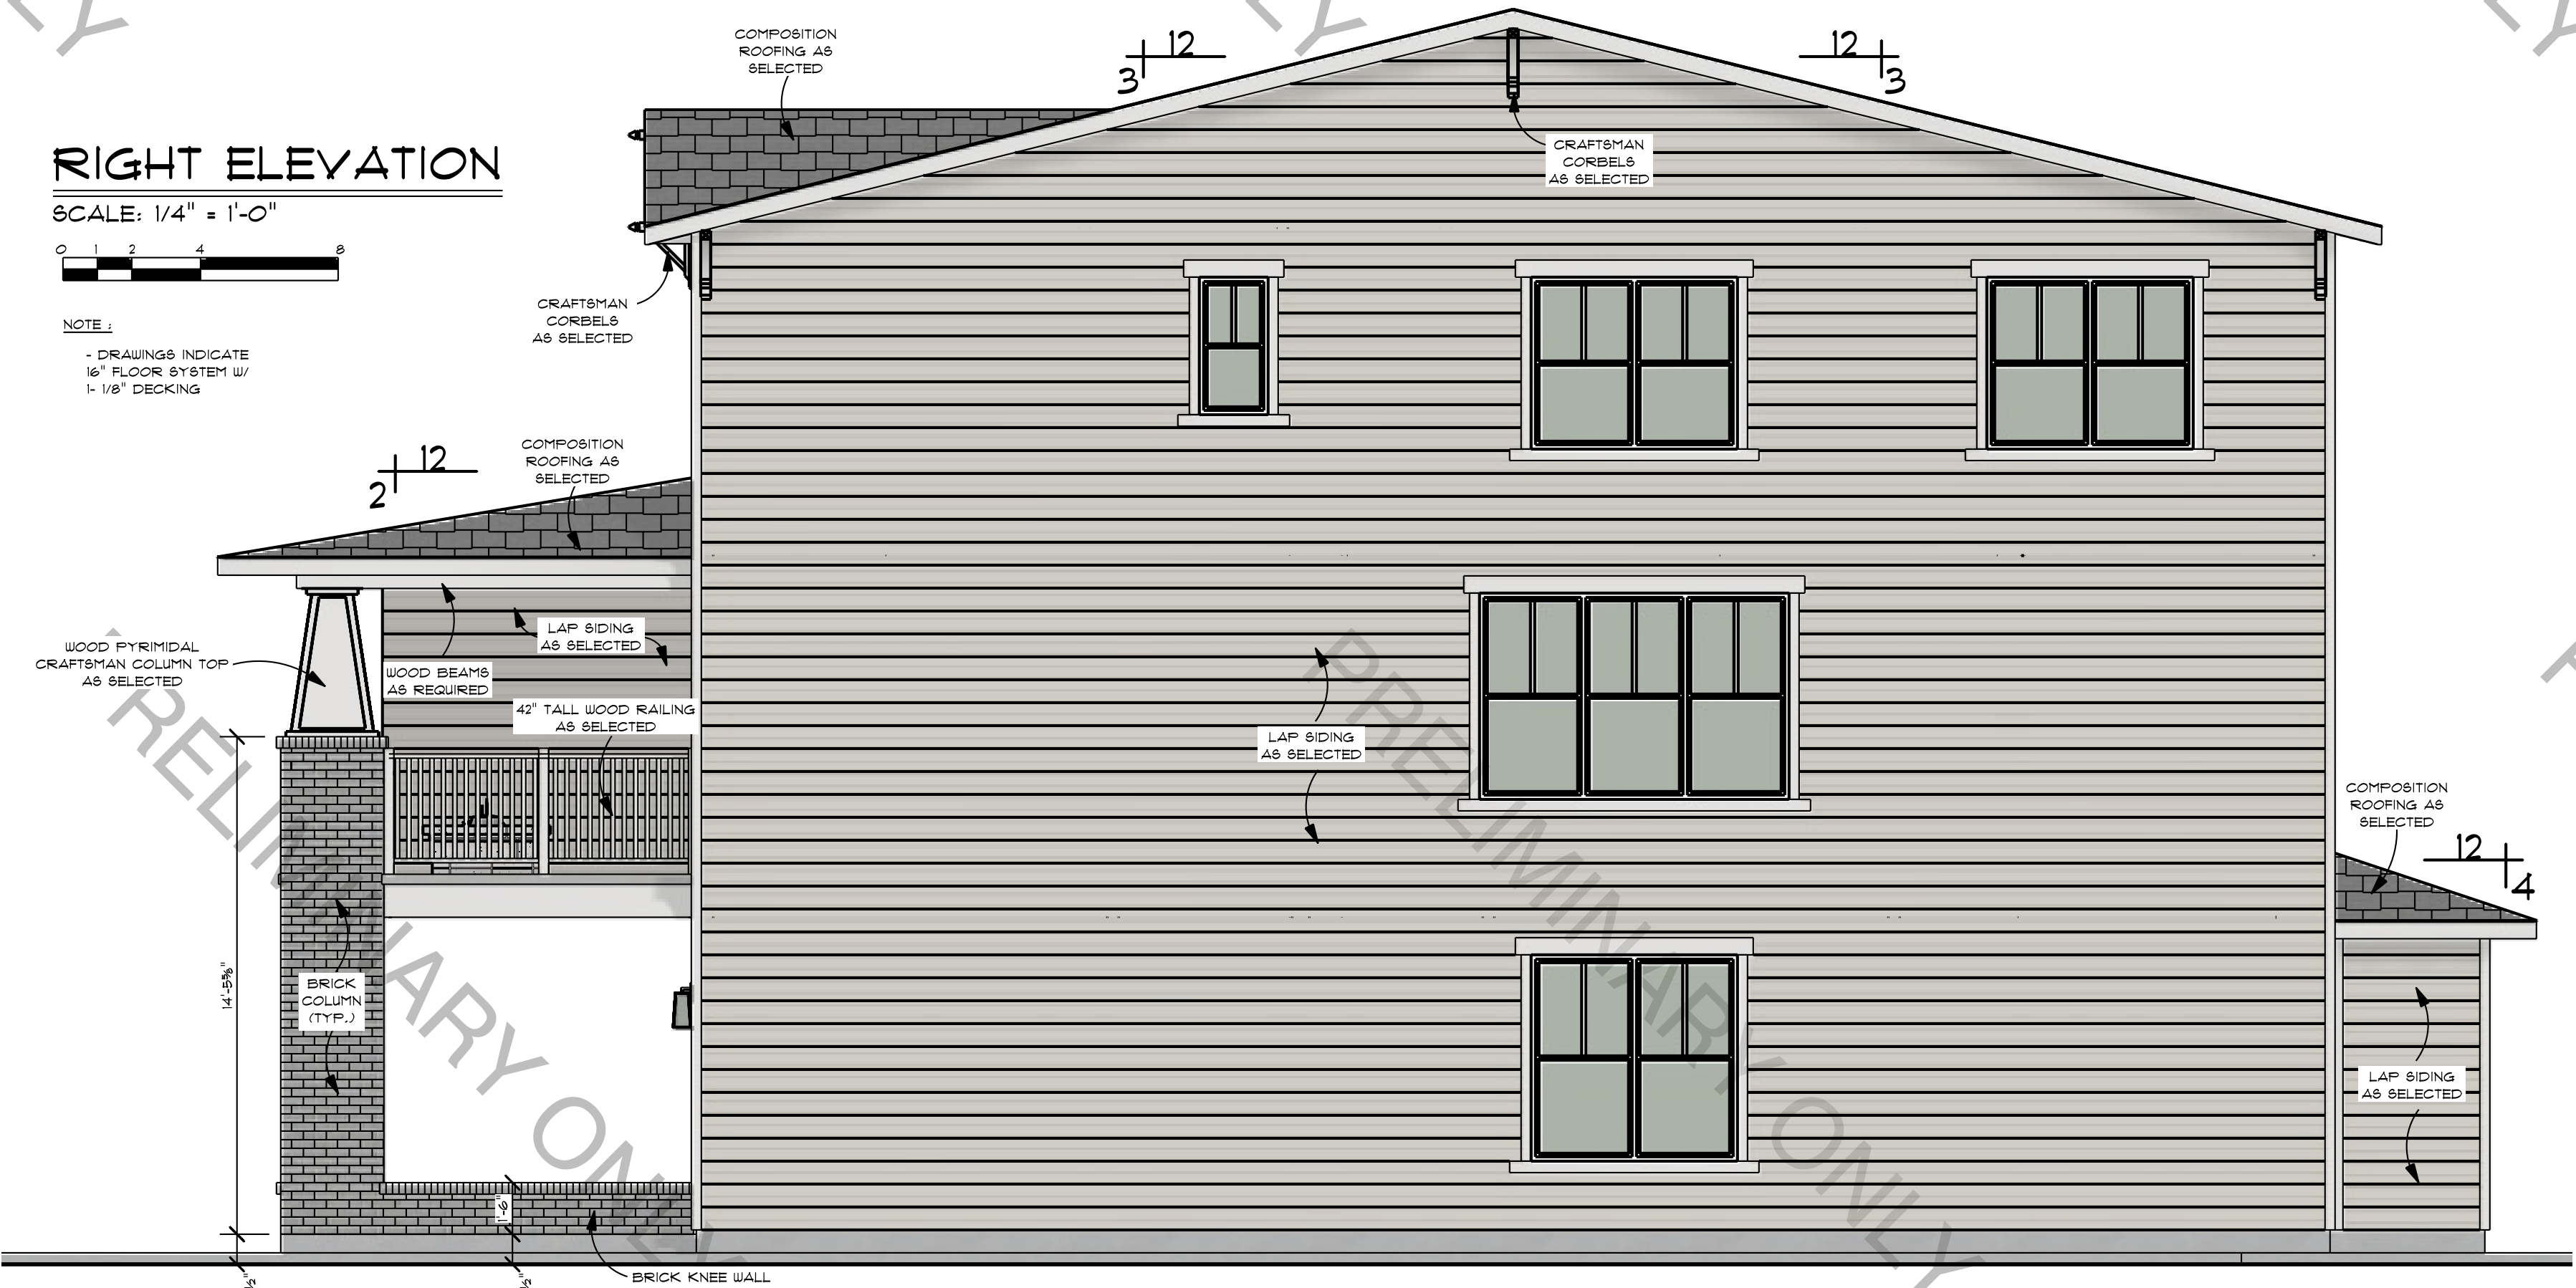

LEFT ELEVATION

SCALE: 1/4" = 1'-0"


NOTE:
- DRAWINGS INDICATE
16" FLOOR SYSTEM W/
1-1/8" DECKING



FRONT ELEVATION


SCALE: 1/4" = 1'-0"

NOTE:
- DRAWINGS INDICATE
16" FLOOR SYSTEM W/
1-1/8" DECKING

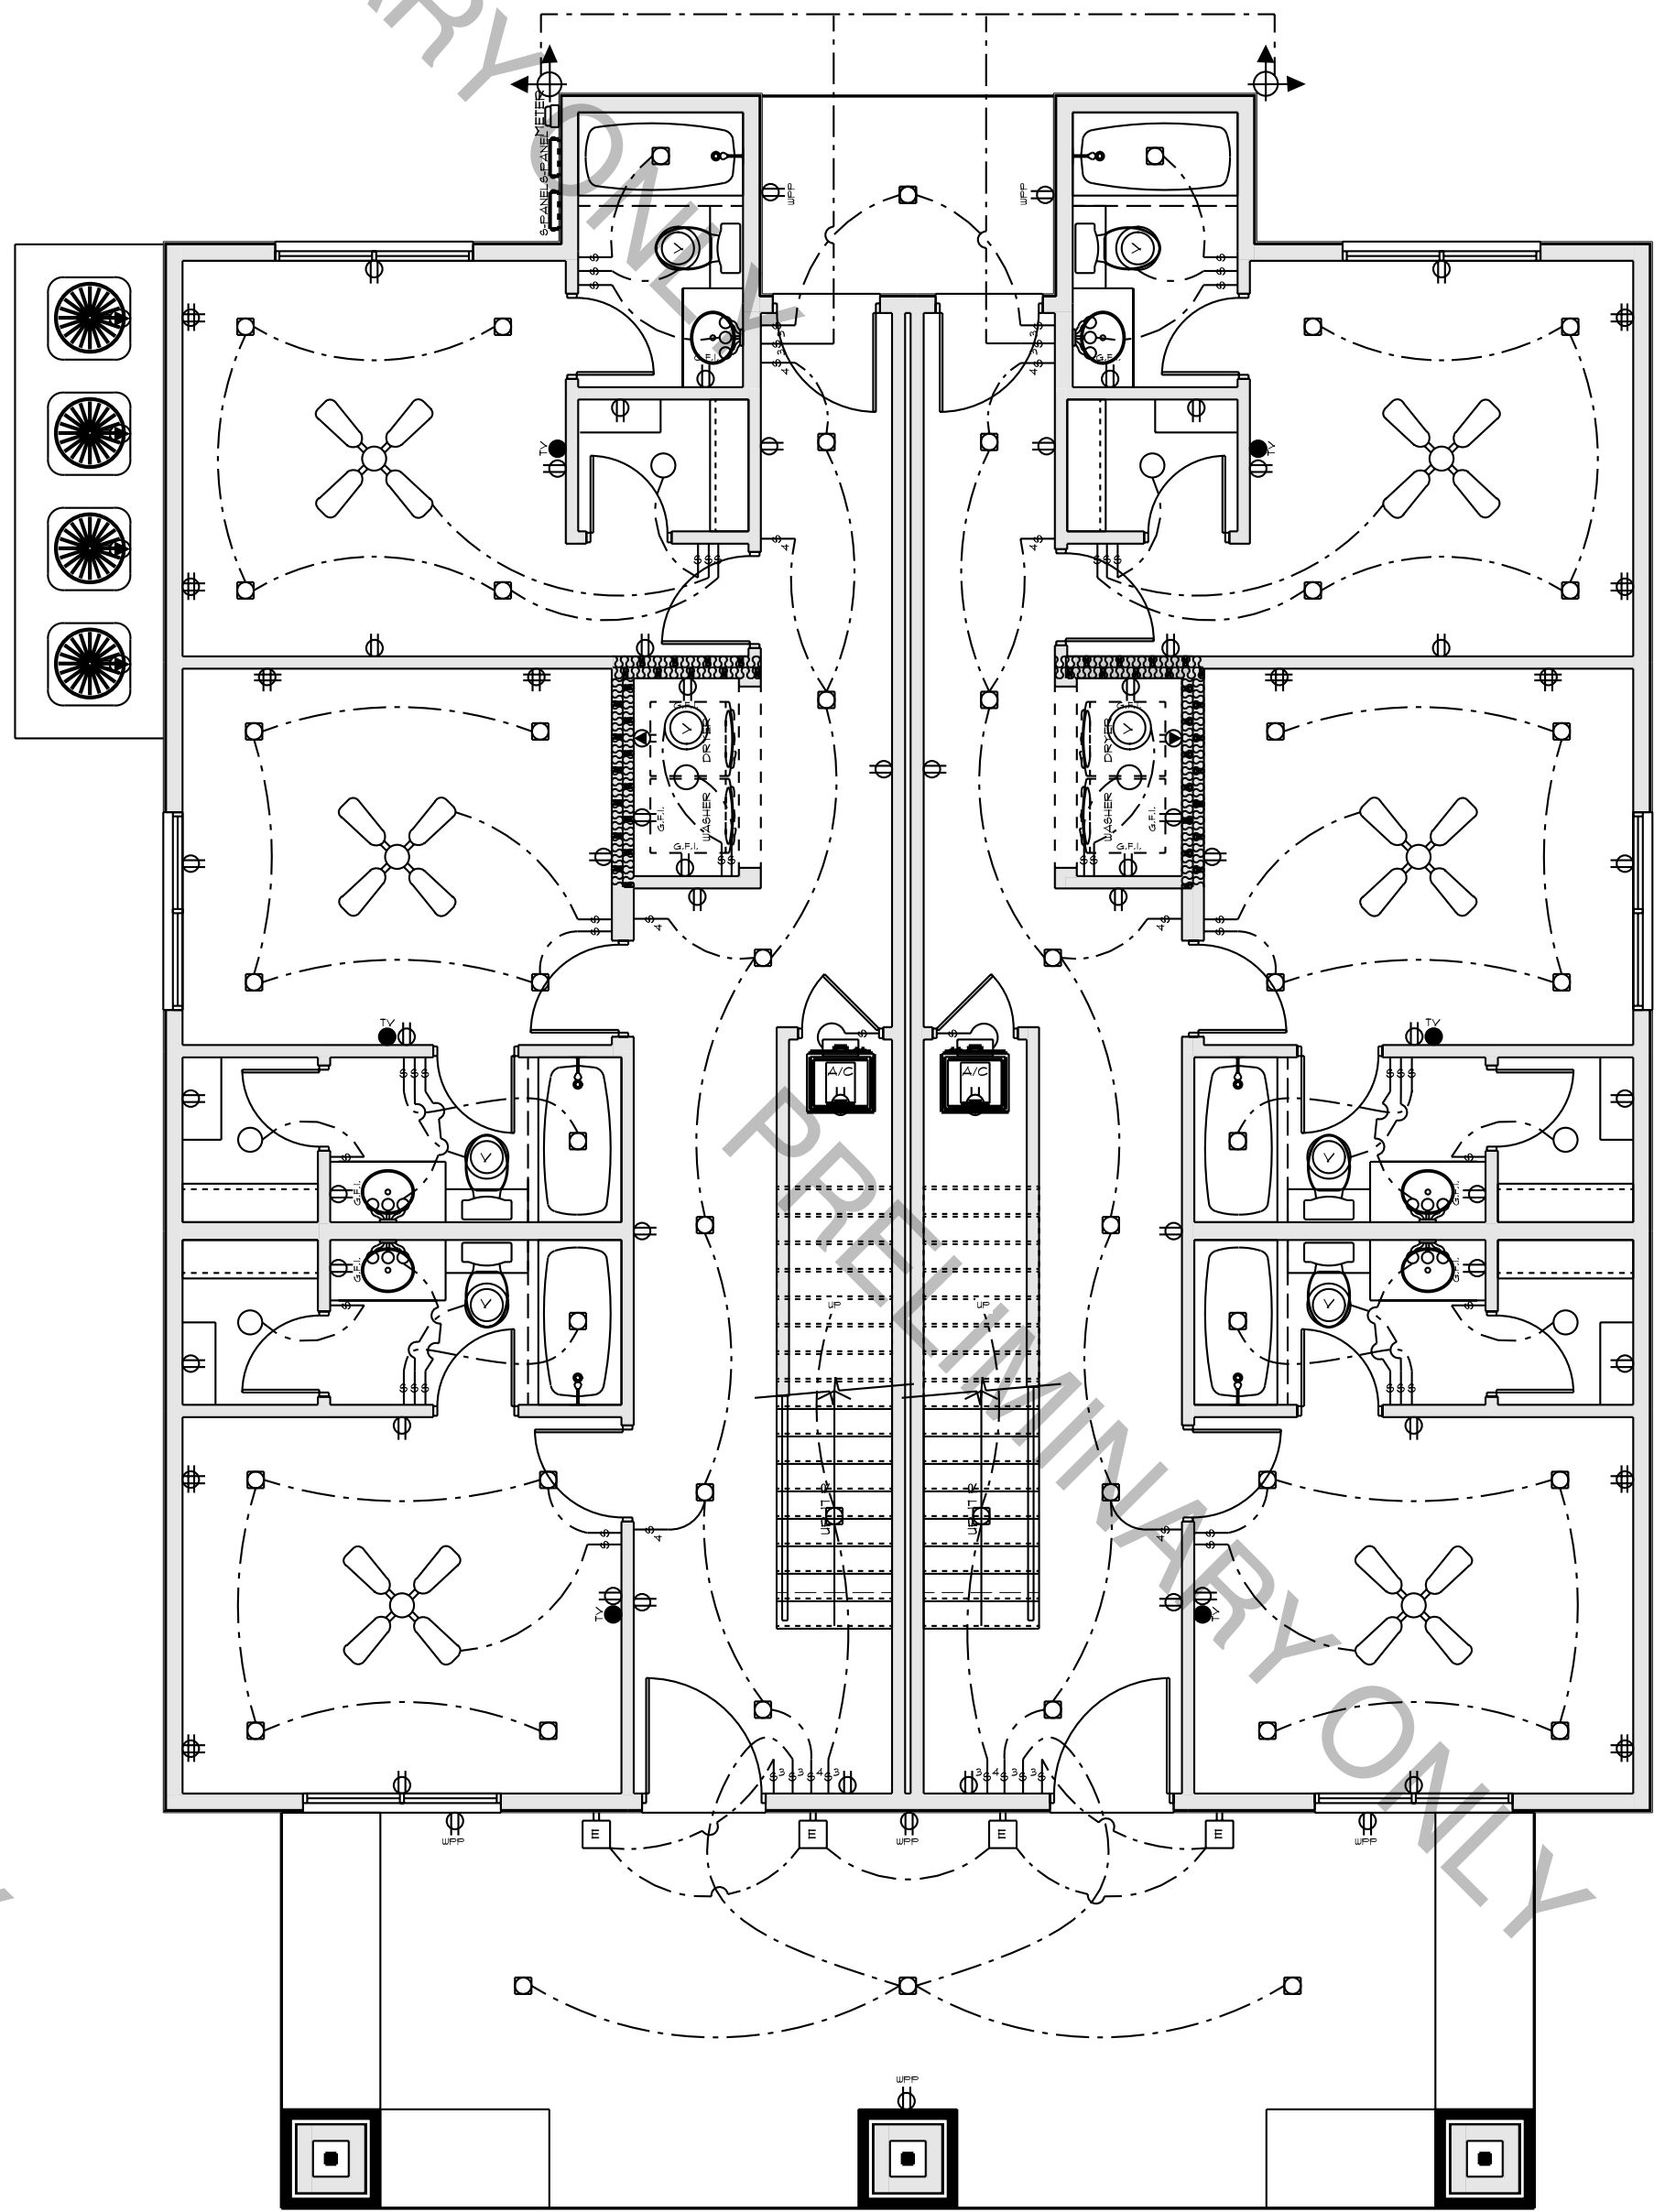


1ST FLOOR ELECTRIC PLAN

SCALE: 3/16" = 1'-0"

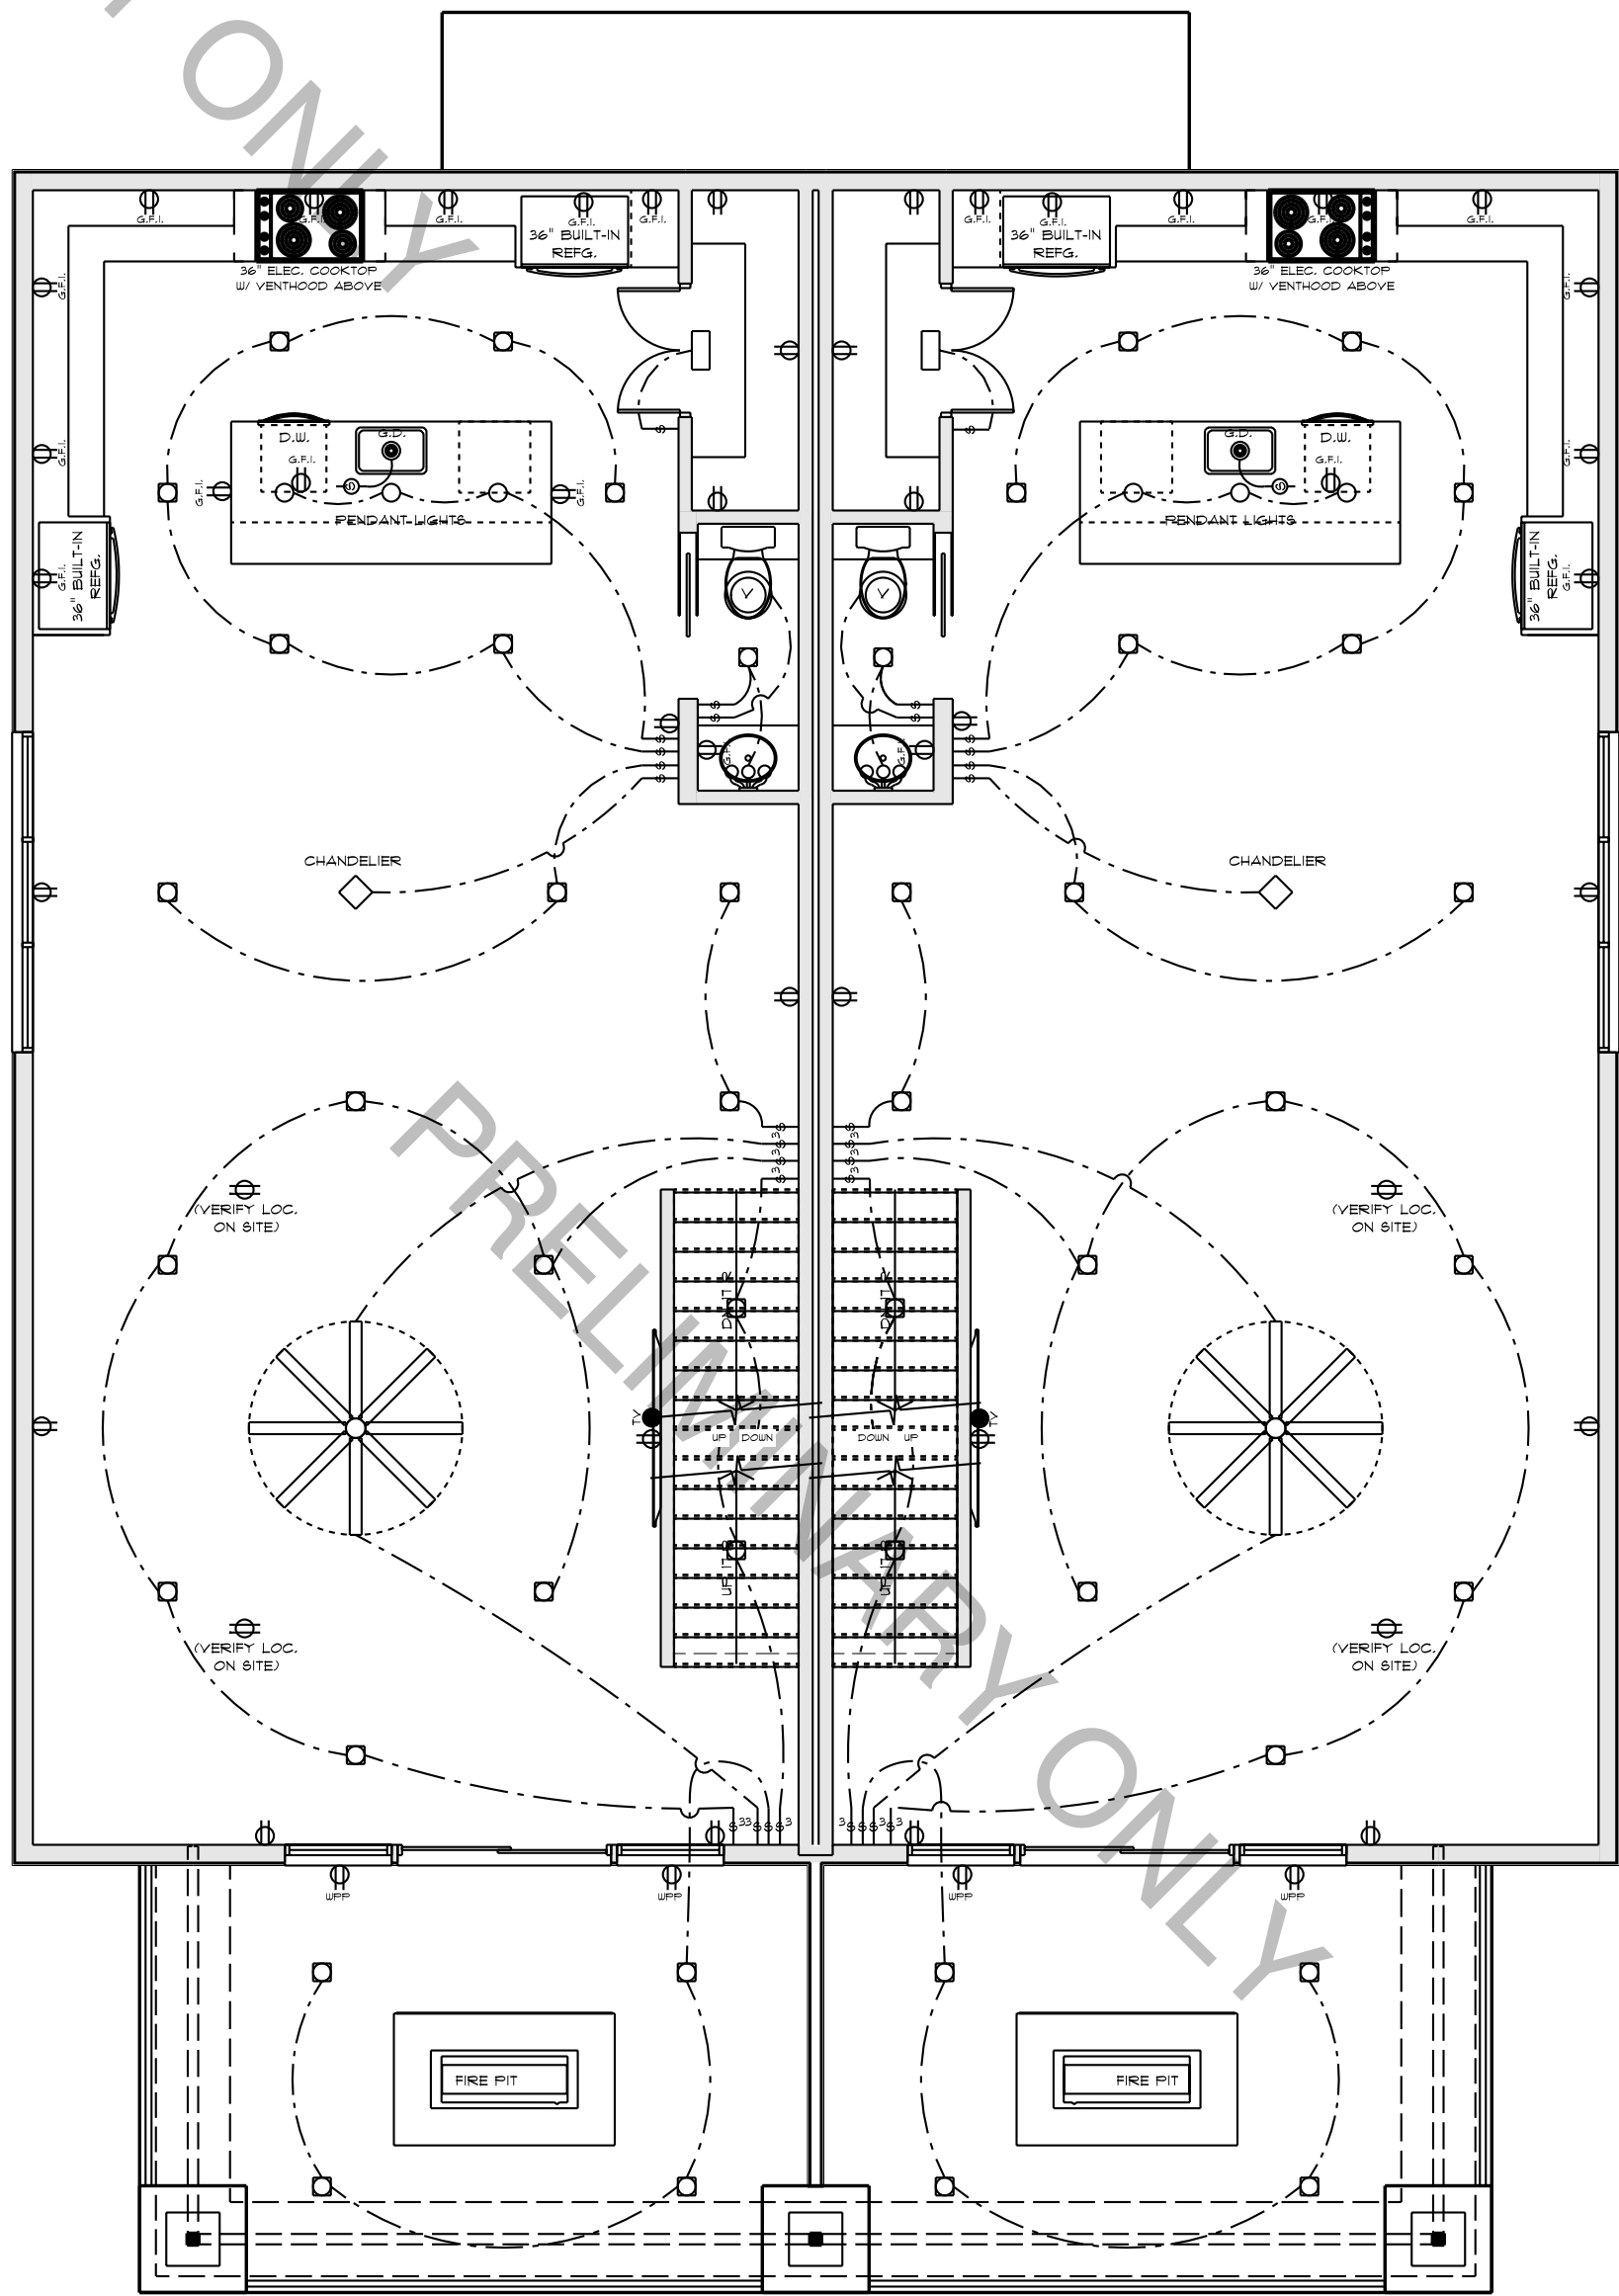

2ND FLOOR ELECTRIC PLAN

SCALE: 3/16" = 1'-0"

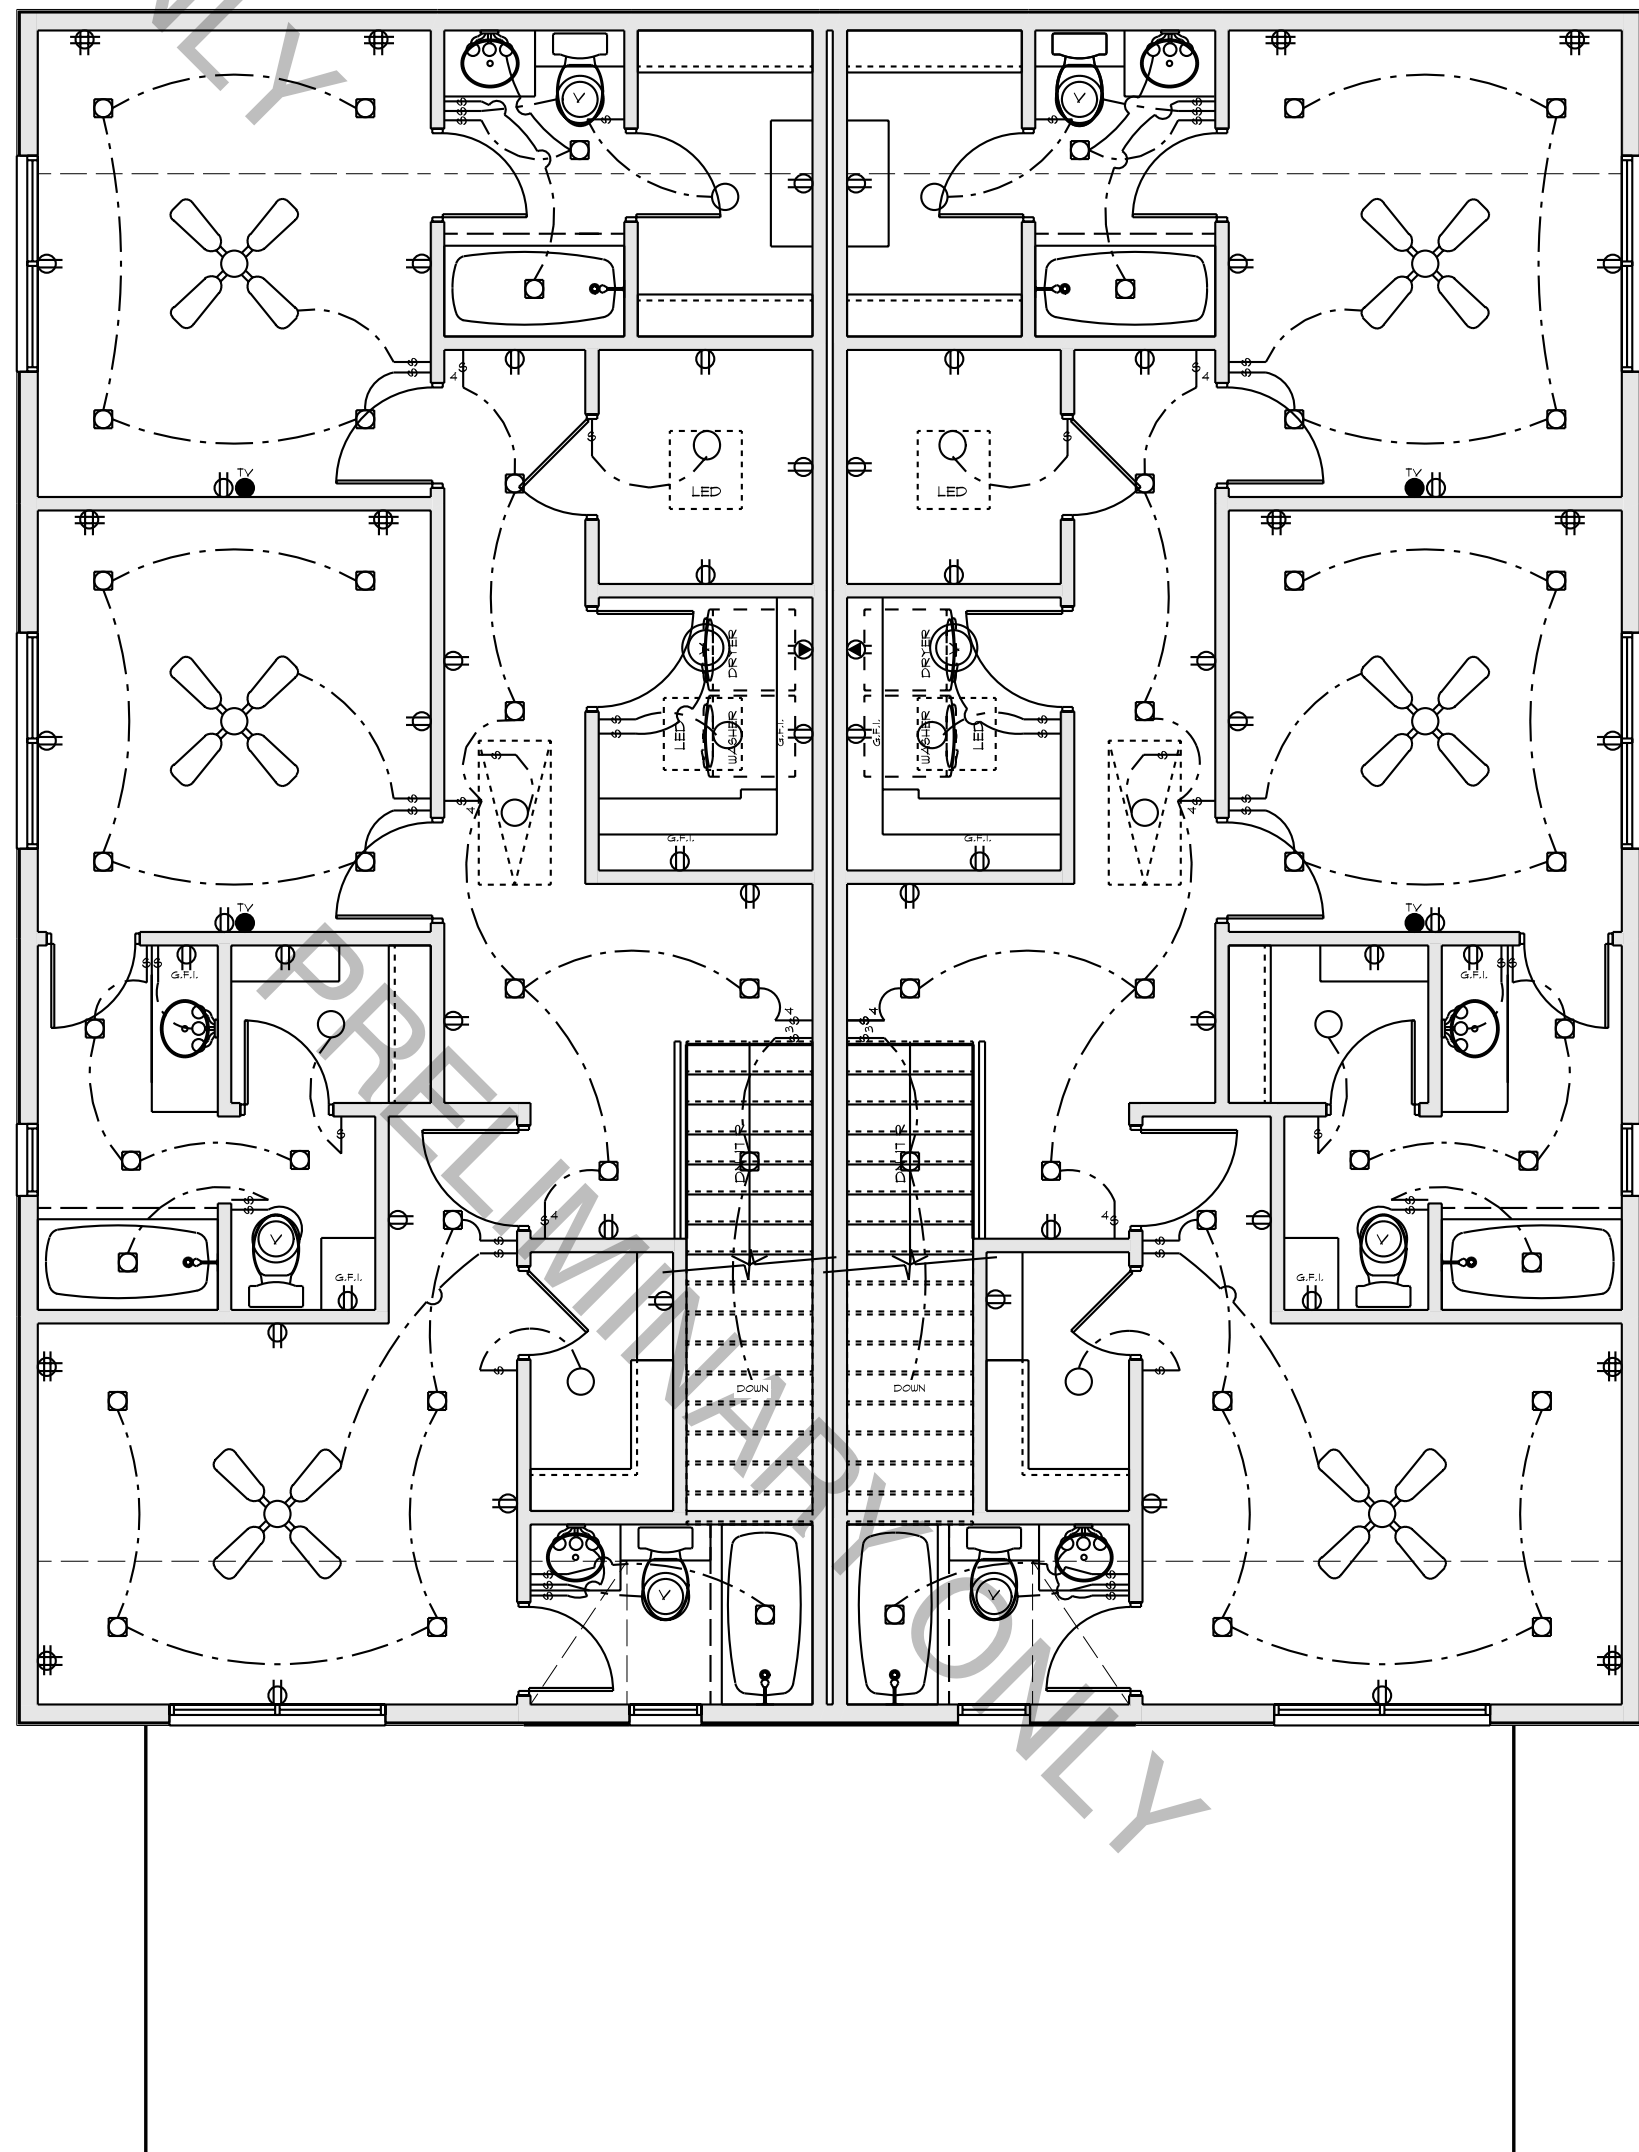

3RD FLOOR ELECTRIC PLAN

SCALE: 3/16" = 1'-0"

ELECTRICAL LEGEND		
ELECTRICAL	COUNT	SYMBOL
Fan	12	
Fan - Big Ass Fan 6'	2	
Garbage Disposal	2	
LED 2 X 2 Light	4	
Light- 6in Rec. Can	147	
Light- Ceiling Mount	16	
Light- Chandelier	2	

ELECTRICAL LEGEND		
ELECTRICAL	COUNT	SYMBOL
Light- Elec. Lantern-6	4	
Light- Flood Light	2	
Light- Pendant Lights	2	
Light- Vanity Light	14	
Light-Closet	4	
Meter Base	1	
Misc.- Service Panel	2	

ELECTRICAL LEGEND		
ELECTRICAL	COUNT	SYMBOL
Outlet- 110v	99	
Outlet- 110v GFI	42	
Outlet- 110v Quadplex	24	
Outlet- 110v WFF	10	
Outlet- 220v	10	
Outlet- Floor Plug	4	
Outlet- TV 4 110v (See Owner for Height)	2	

ELECTRICAL LEGEND		
ELECTRICAL	COUNT	SYMBOL
Switch - Single	102	
Switch - Jamb	4	
Switch- 3 Way	24	
Switch- 4 Way	19	
Switch- Air Switch	2	
Vent	18	