


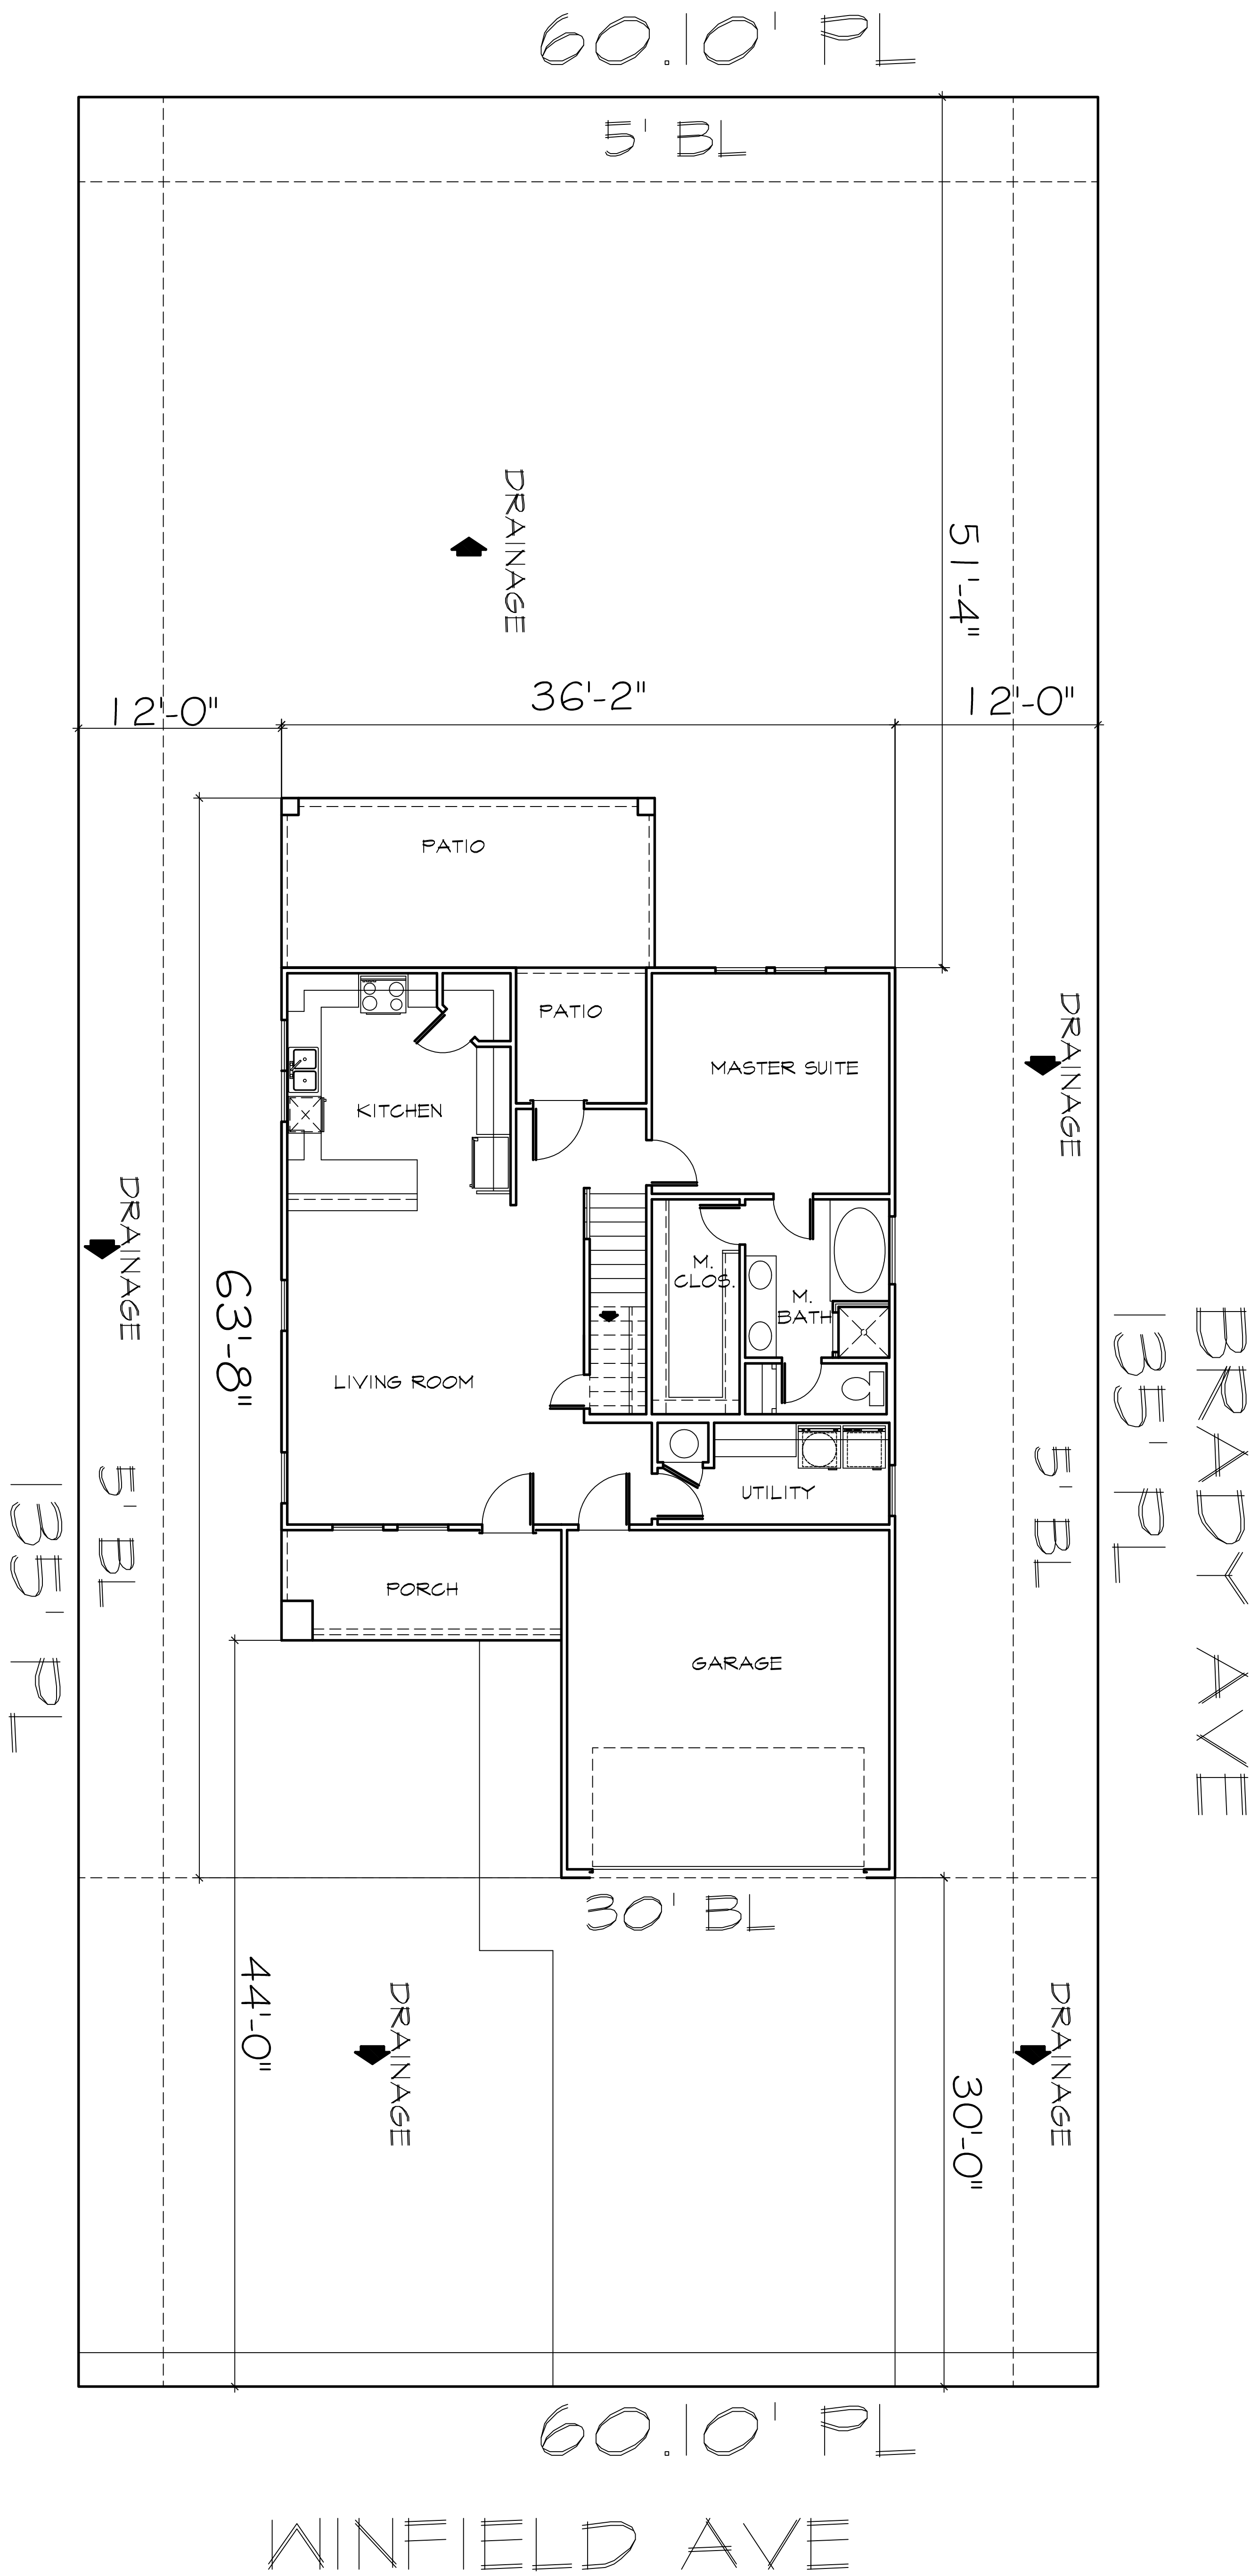

1



038-2427-0624
REV
P/m/V/c

GOLDEN STAR ROCK
INVESTMENTS

LOT:	BLK:	20-5
ADDRESS:	3937 WINFIELD AV	
SUBDIVISION:	WINDSOR PLACE ADD	
CITY:	FORT WOTH	
COUNTY:	TARRANT	
STATE:	TX	
SCALE:	3/16"	

Doug Herron.com
Residential Designs
817-538-2910

  EMAIL: dougsplans@aol.com WEBSITE: dougherron.com



LOT:	BLK:	6-4
ADDRESS:	3820 WINDFILD AVE	
SUBDIVISION:	WINDSOR PLACE ADD	
CITY:	FORT WOTH	
COUNTY:	TARRANT	
STATE:	TX	
SCALE:	1/4"	

EMAIL: dougsplans@aol.com WEBSITE: dougherron.com




SCALE: 1/4"=1'-0"




②

Plan No: 038-2427-0624

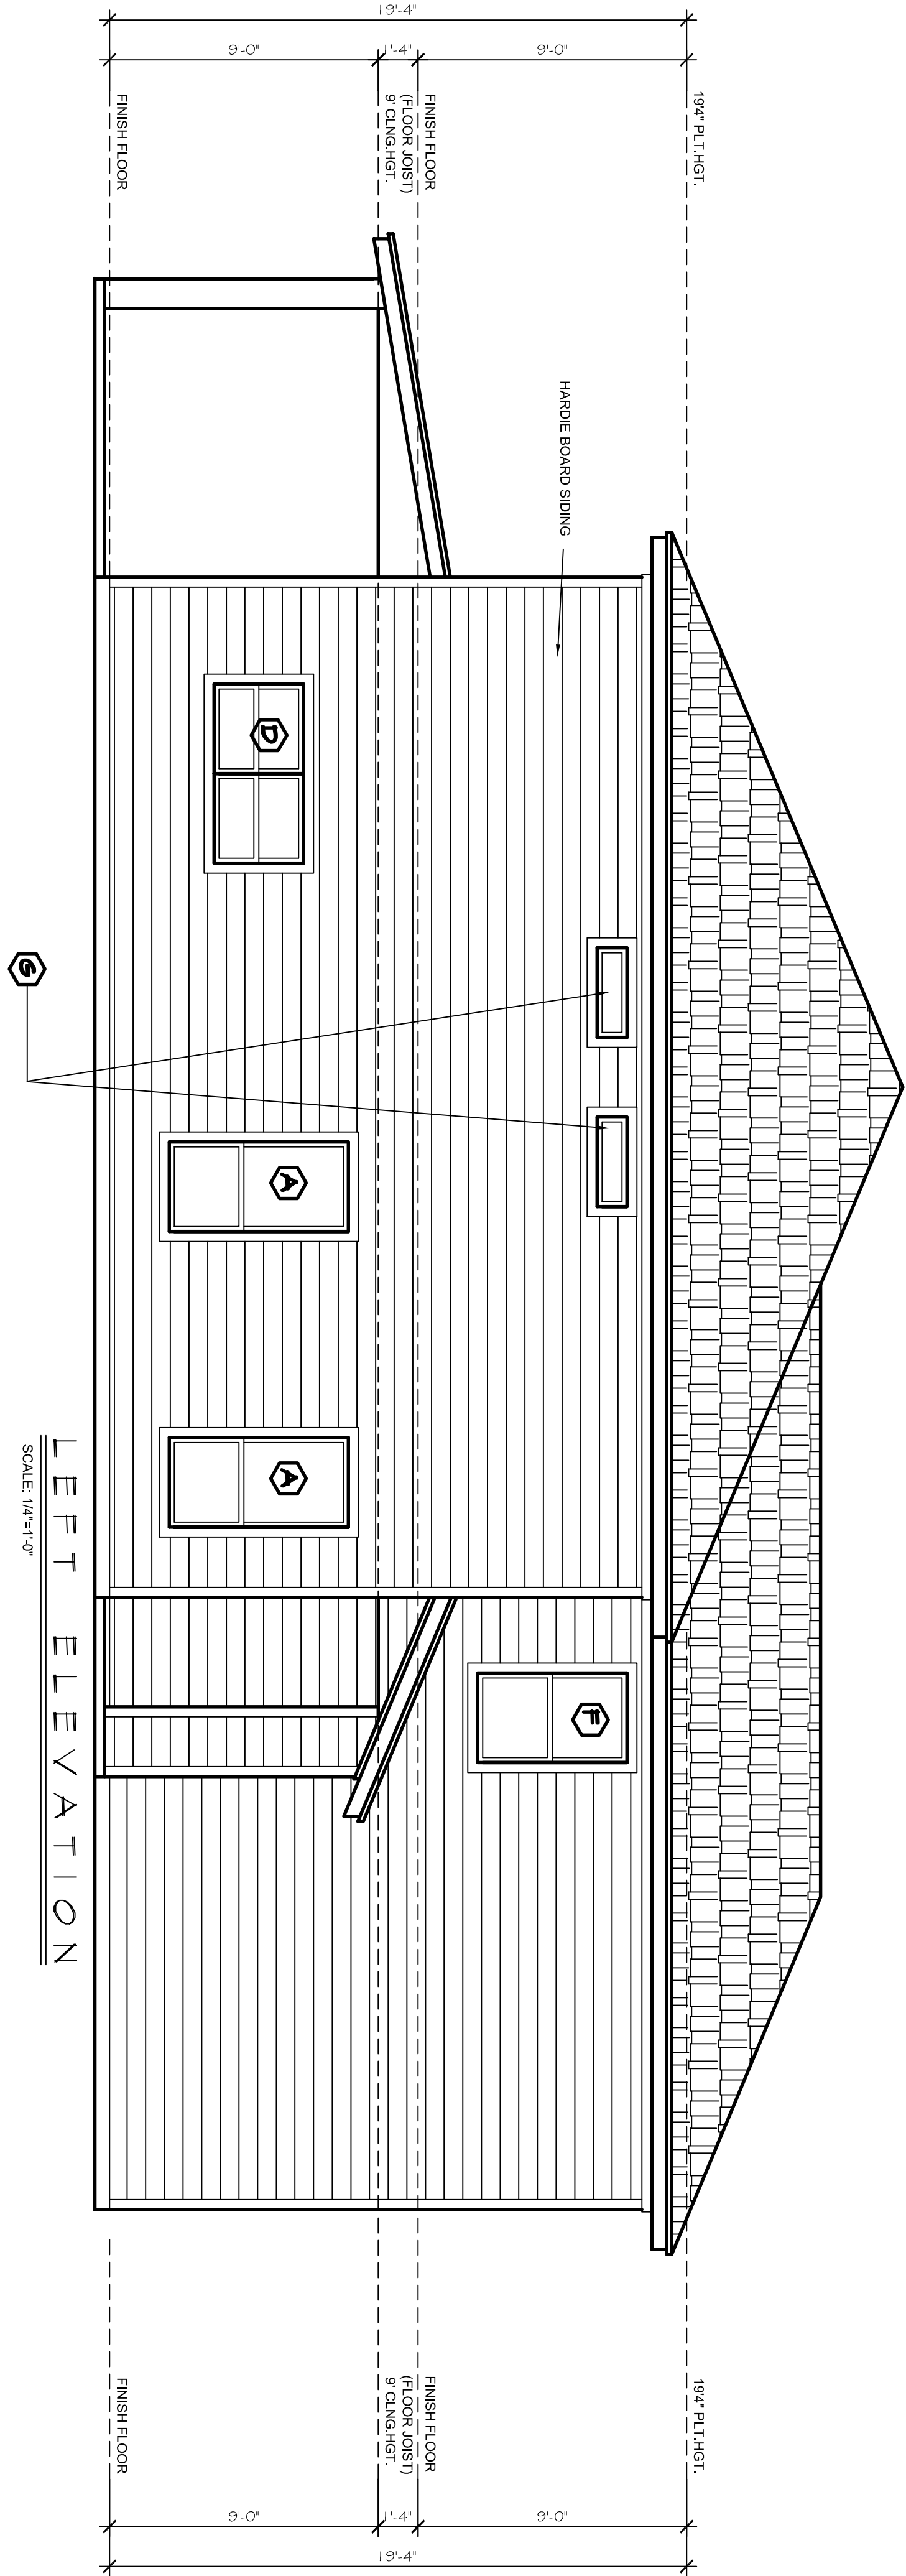

LEFT ELEVATION

SCALE: 1/4"=1'-0"

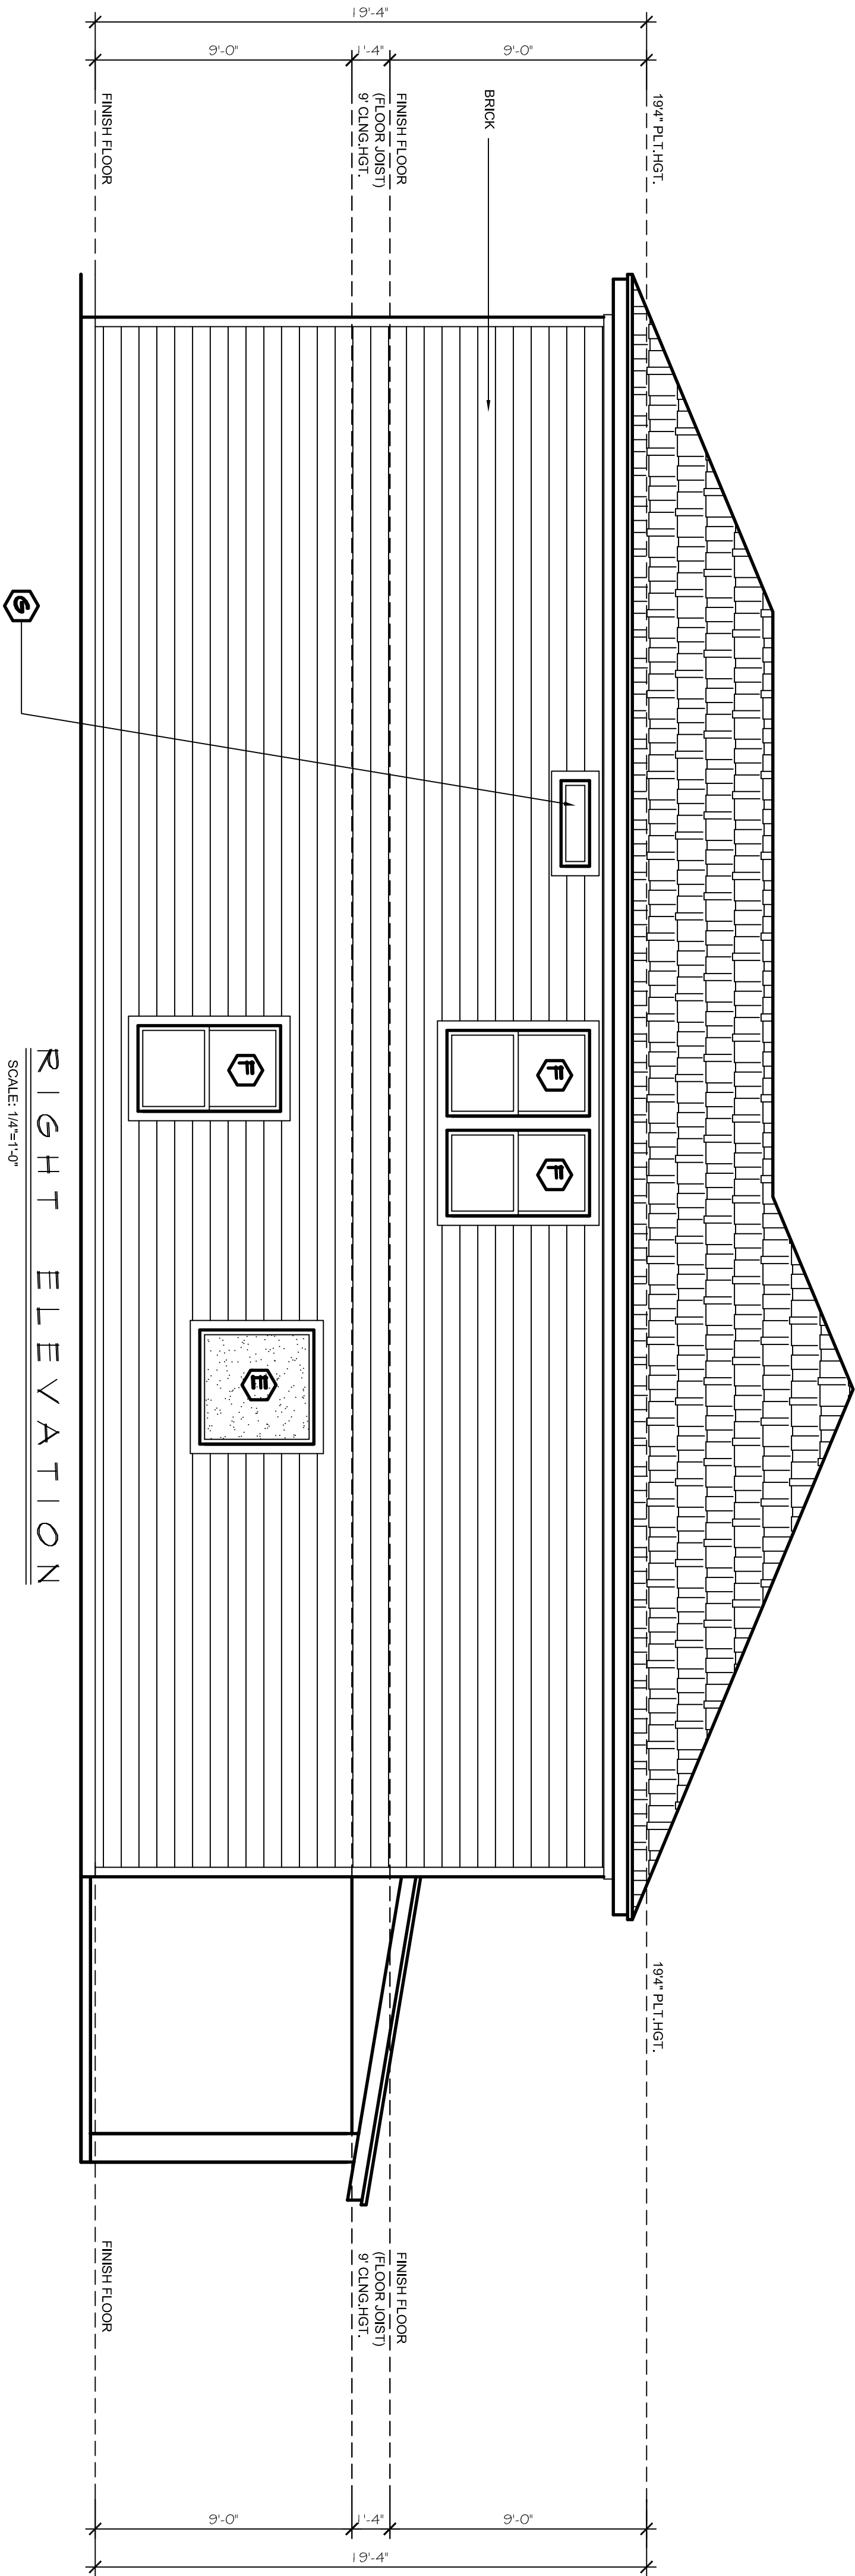

RIGHT ELEVATION

SCALE: 1/4"=1'-0"

LOT:	BLK:	6-4
ADDRESS:		3820 WINDFIELD AVE
SUBDIVISION:		WINDSOR PLACE ADD
CITY:		FORT WOTH
COUNTY:		TARRANT
STATE:		TX
SCALE:		1/4"

 
 
Doug Herron.com
Residential Designs
817-538-2910

EMAIL: dougsplans@aol.com WEBSITE: dougherron.com

P/m No.

038-2427-0624


4



Doug Herron.com
Residential Designs
817-538-2910


EMAIL: dougsplans@aol.com WEBSITE: dougherron.com

ELECTRICAL SCHEDULE	
	BLOCK FOR OPTIONAL CEILING FAN W/ LIGHT KIT
	RECESSED INCANDESCENT
	RECESSED SPOT
	CEILING MOUNTED FIXTURE
	WALL MOUNTED FIXTURE/COACH LIGHT
	UNDER CABINET FLOURESCENT
	OVERHEAD PULL CHAIN
	EXHAUST FAN WITH LIGHT
	EXHAUST FAN
	DOUBLE FLOOD LIGHTS
	4' (2 BULB) FLOURESCENT
	SWITCH
	SWITCH WITH DIMMER
	110-VOLT OUTLET
	220-VOLT OUTLET
	WEATHERPROOFED GROUNDED 110-VOLT
	GROUNDED 110-VOLT OUTLET
	1/2 HOT 110-VOLT OUTLET
	CEILING 110-VOLT OUTLET
	FLOOR 110-VOLT OUTLET AND/OR UNDER
	PHONE
	TV CABLE
	SMOKE DETECTOR
	INTERCOM/SPEAKER
	MASTER INTERCOM/SPEAKER
	ELECTRIC EYE
	SECURITY KEY PAD
	DOORBELL
	CHIME
	GAS HOOK-UP
	HOSE BIBB
	ELECTRICAL PANELS

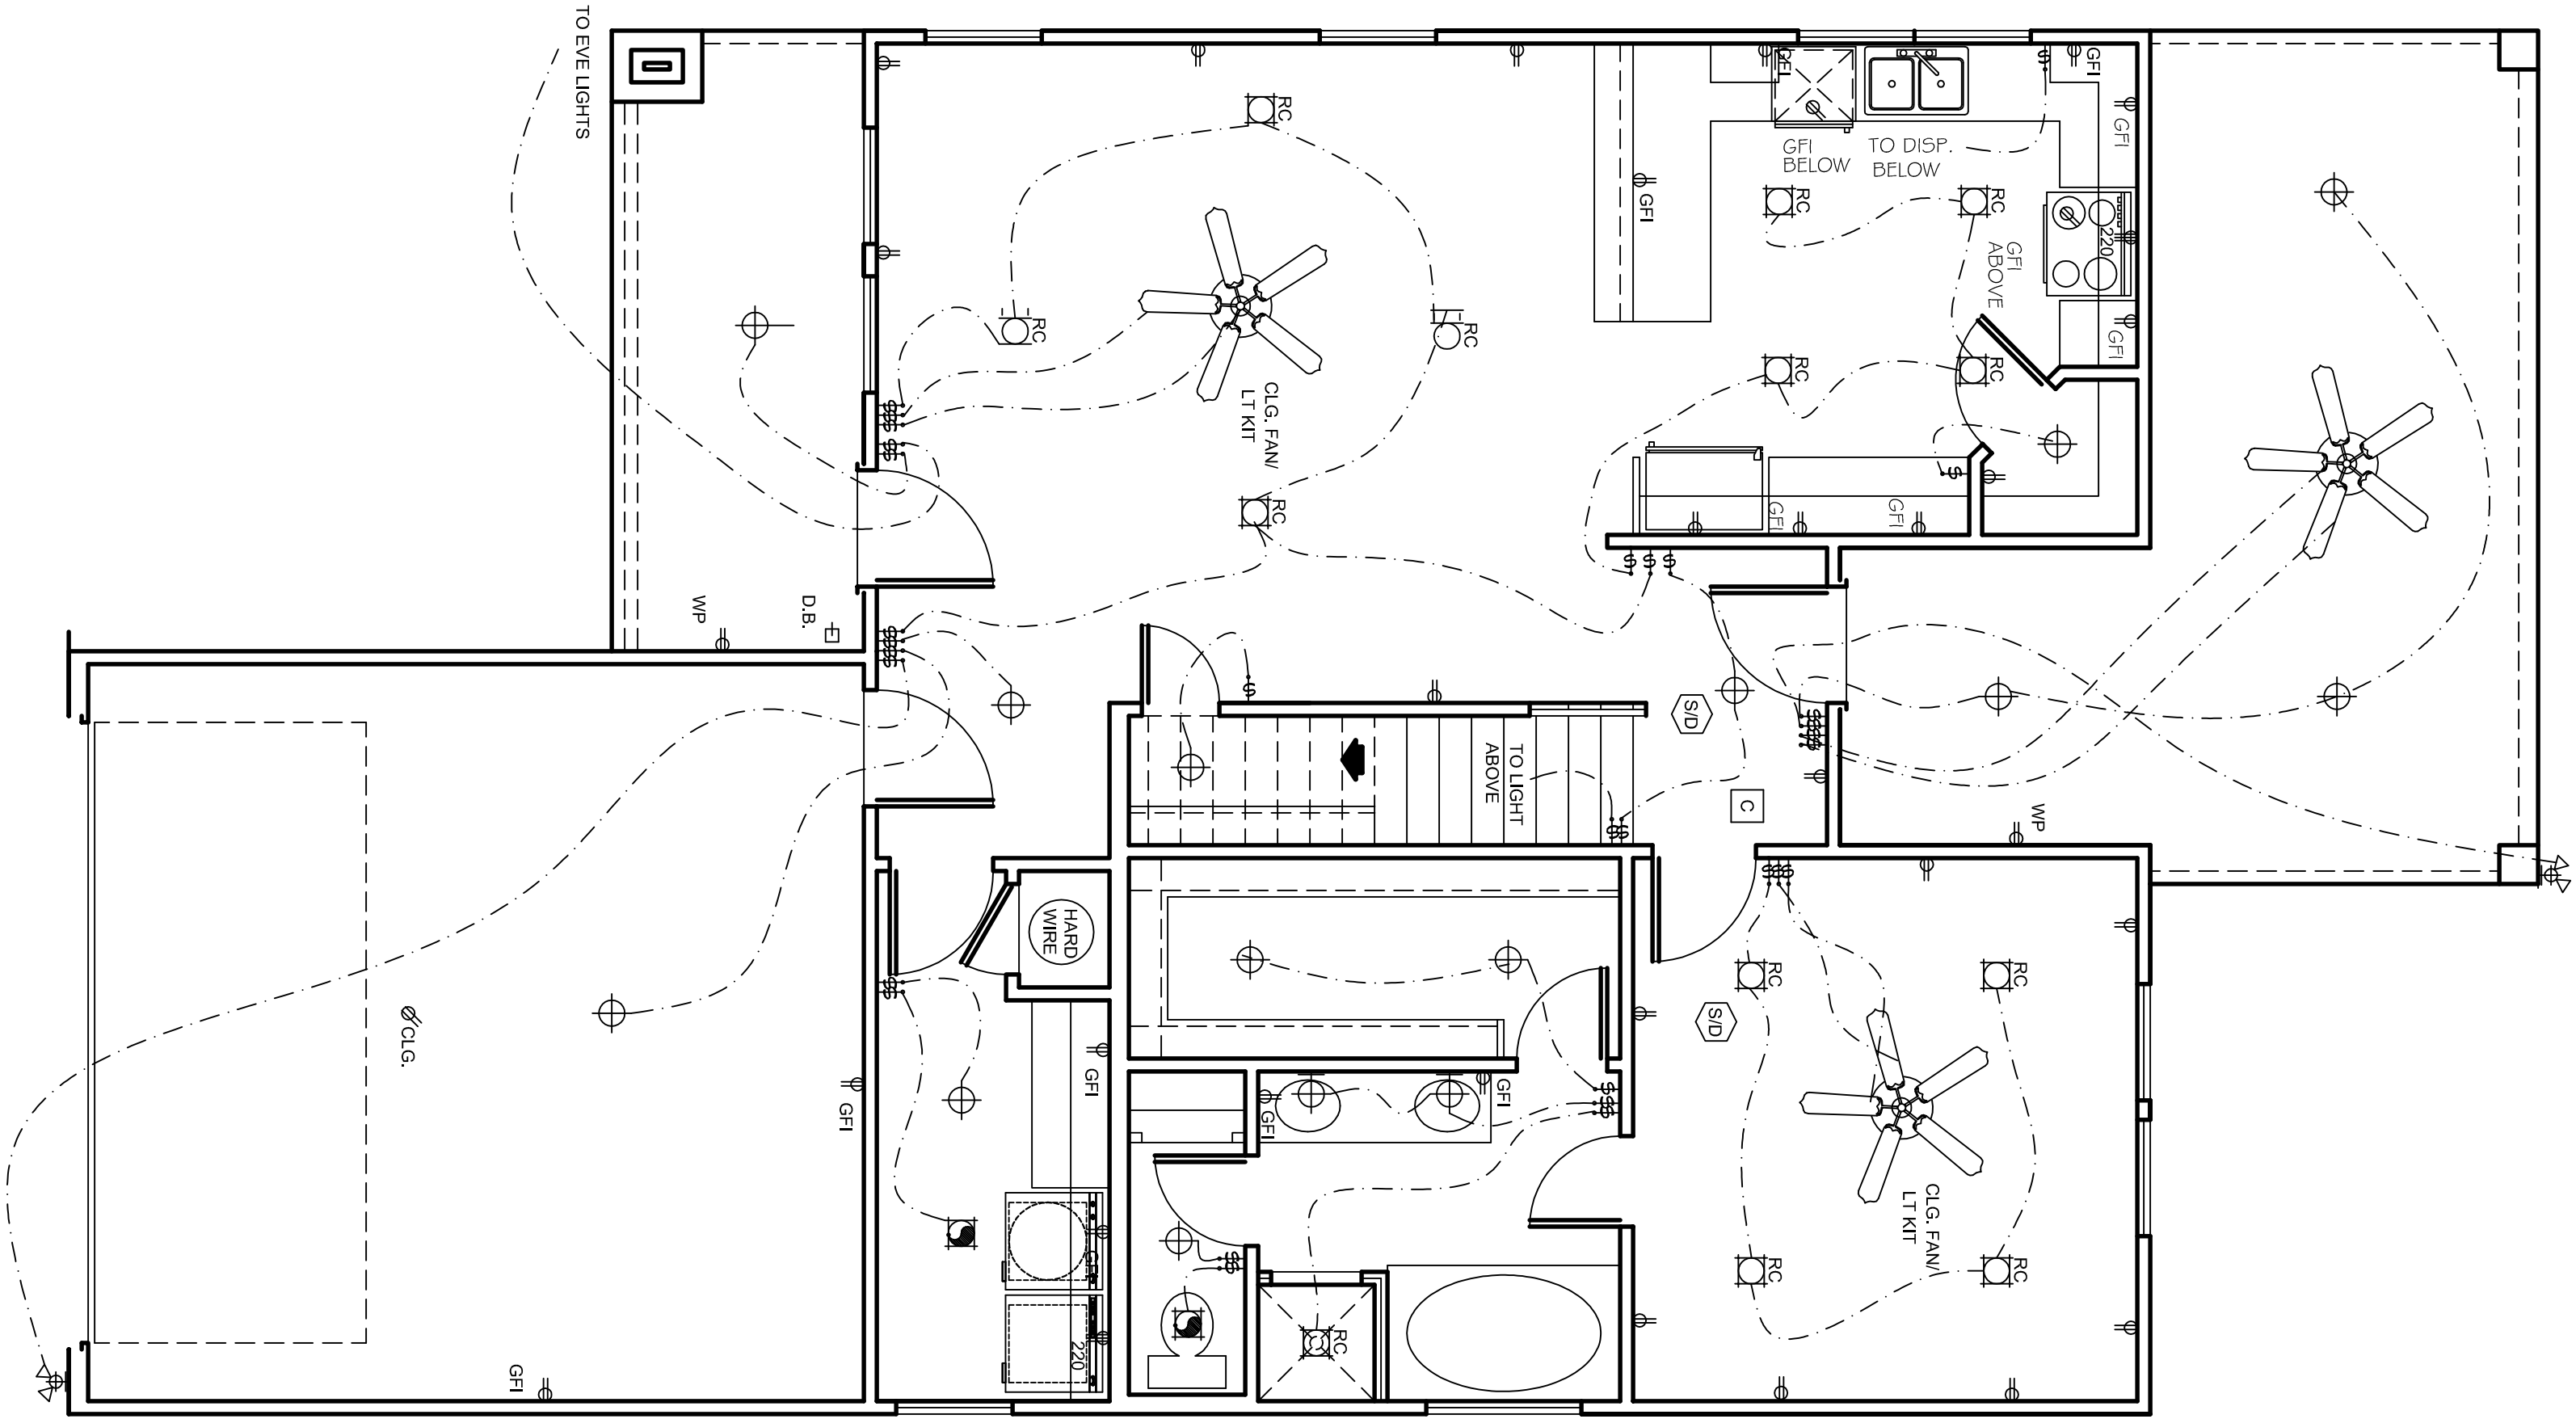

FIRST FLOOR ELECTRIC PLAN

SCALE: 1/4"=1'-0"

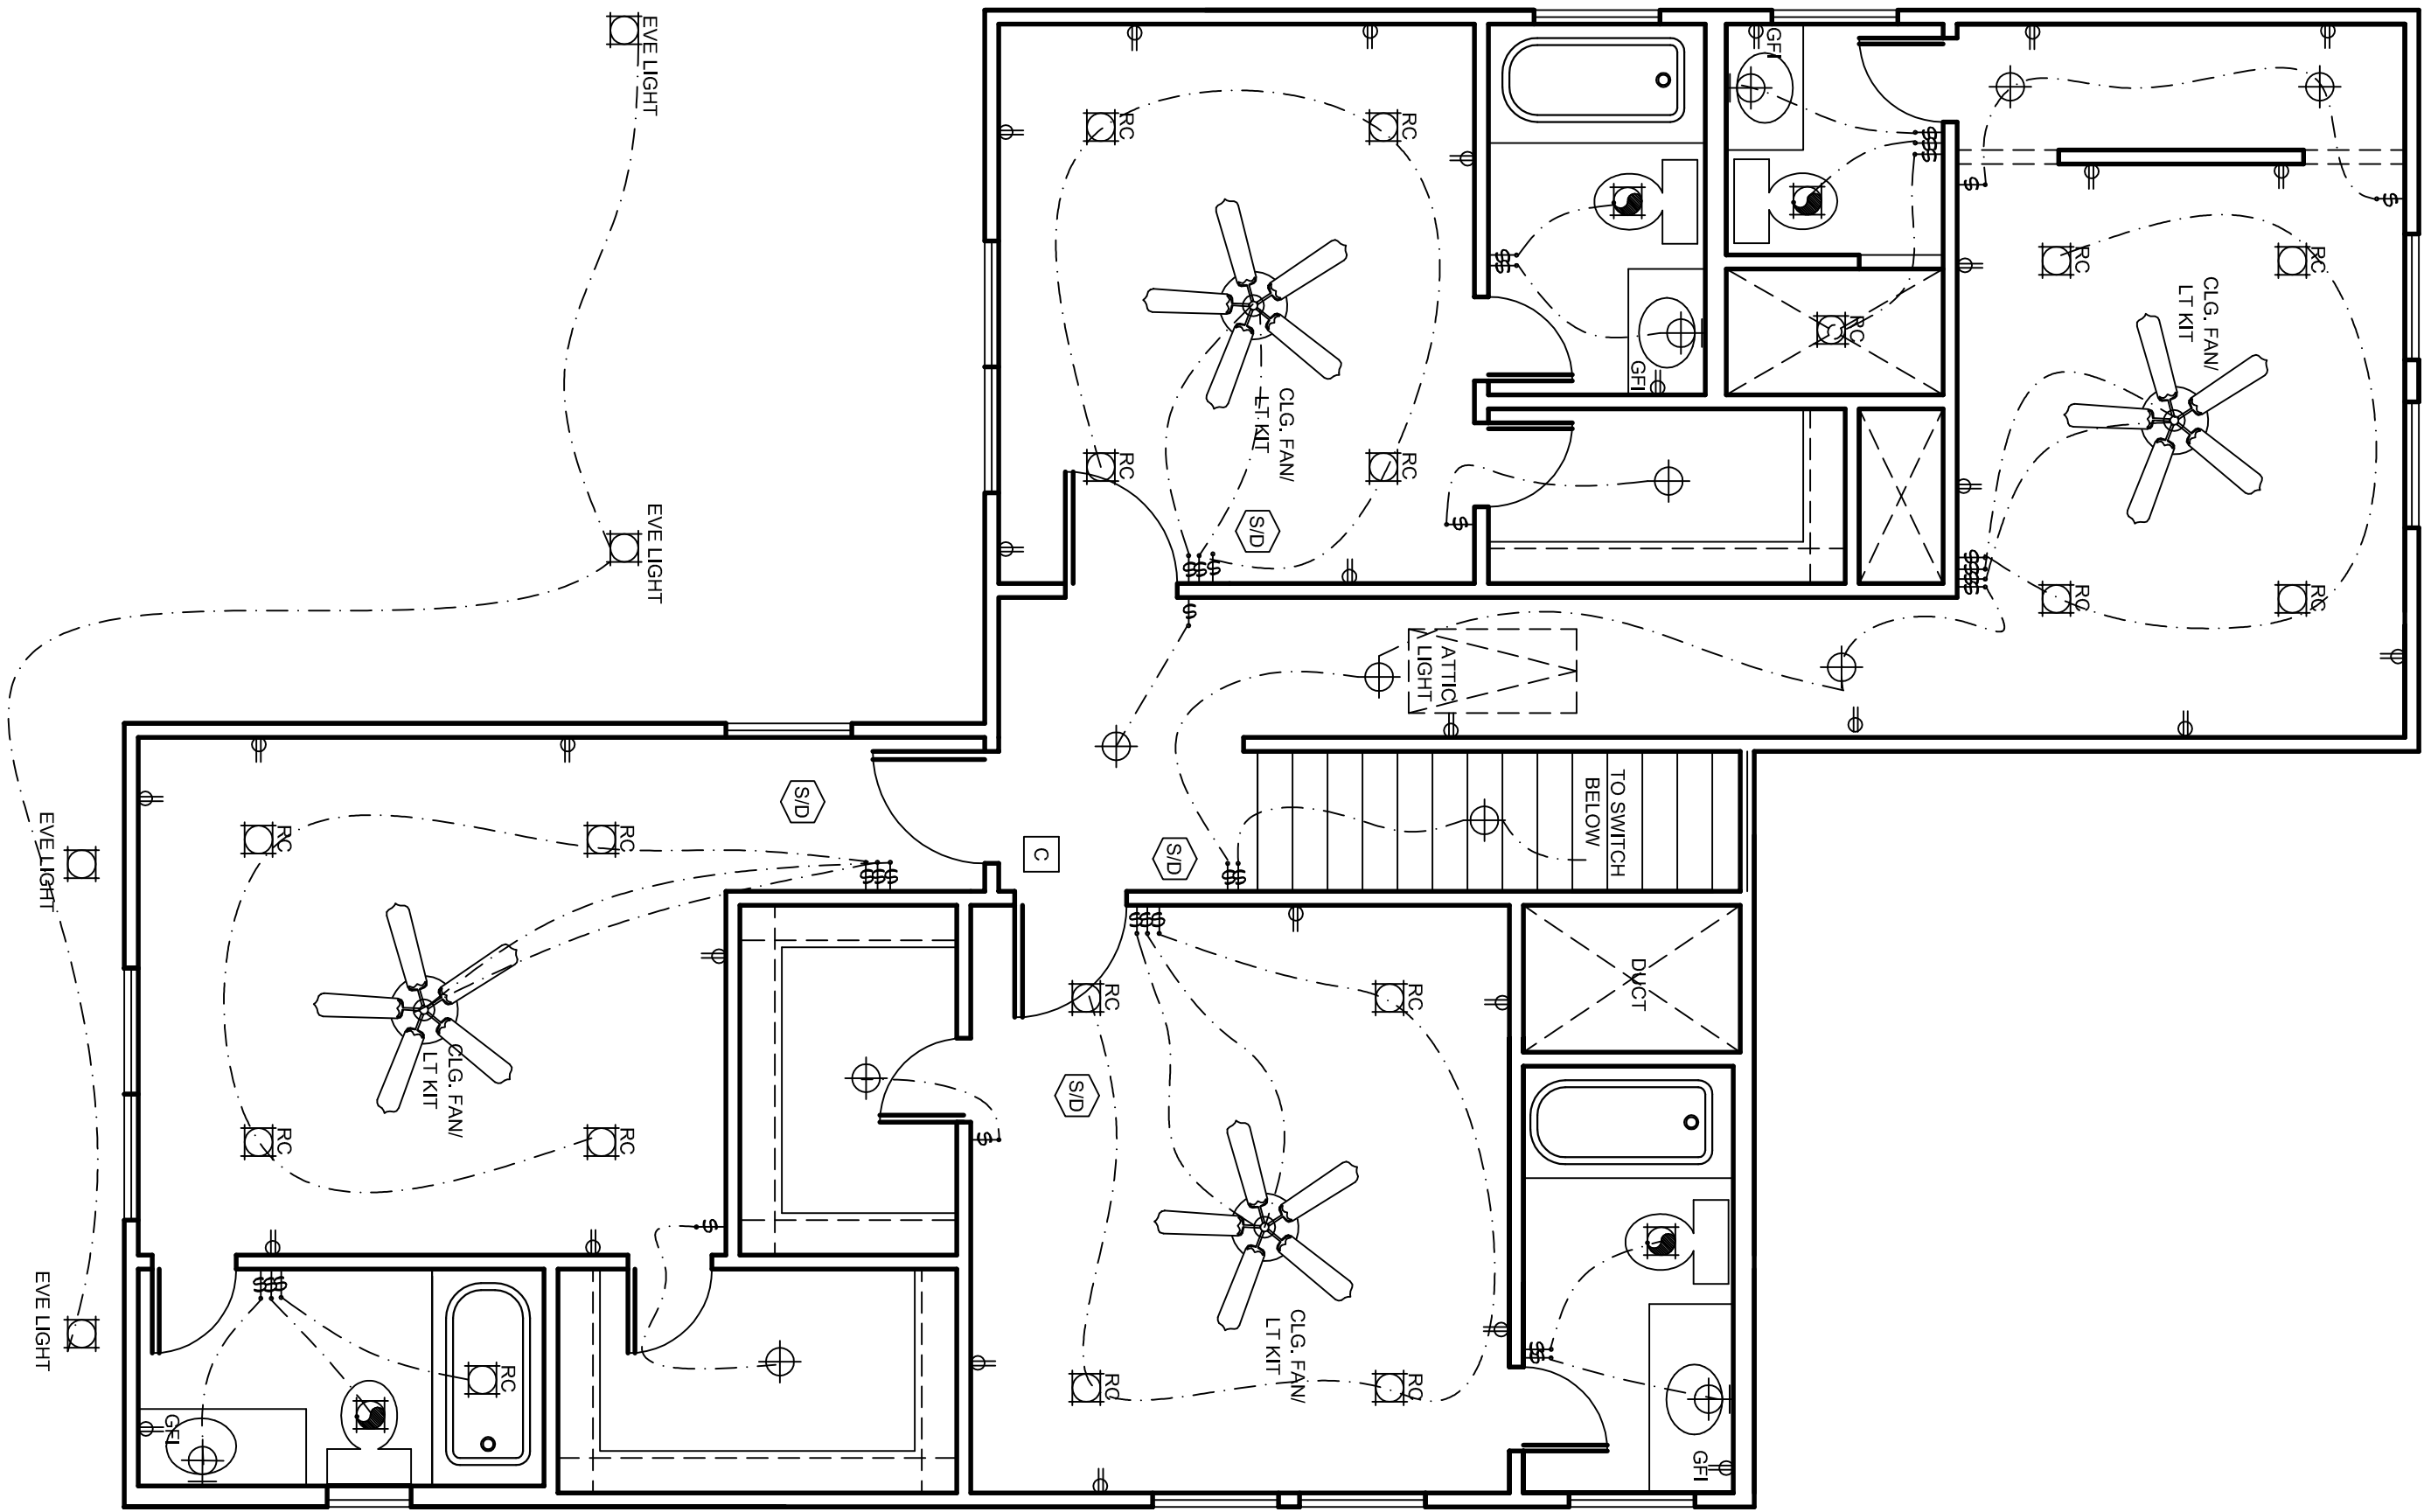

SECOND FLOOR ELECTRIC PLAN

SCALE: 1/4"=1'-0"

Doug Herron.com
Residential Designs
817-538-2910

EMAIL: dougsplans@aol.com WEBSITE: dougherron.com

LOT:	BLK:	6-4
ADDRESS:		3820 WINDFIELD AVE
SUBDIVISION:		WINDSOR PLACE ADD
CITY:		FORT WOTH
COUNTY:		TARRANT
STATE:		TX
SCALE:		1/4"

P/In No.

038-2427-0624

6